

N.W. 1/4, SEC. 26, T. 21 N., R. 4 E., W.M.


- 12 CONNECT TO EX. PIG PORT (RAM NIWAS CHURCH PIG PORT #3, LUD PROJECT NUMBER 6308021)  
1-6" ISOLATION GATE VALVE W/BOX  
1-6" HDPE DR 11 SPOOL
- 13 1-6" ISOLATION GATE VALVE W/BOX
- 14 1-6" ISOLATION GATE VALVE W/BOX
- 15 1-6" HDPE DR 11 WYE  
1-6" HDPE DR 11 45° BEND  
1-6" ISOLATION GATE VALVE W/ BOX
- 16 1-6" ISOLATION GATE VALVE W/BOX  
1-6" FORCE MAIN CLEANOUT W/PIG PORT #5  
1-6" HDPE DR 11 SPOOL

**VERTICAL DATUM :**

NAVD 88

**BENCH MARK :**

KING COUNTY SURVEY CONTROL POINT No. 6905, SW CORNER OF SECTION 27, T 24 N, R 4 E, W.M., CONCRETE MONUMENT WITH LEAD AND BRASS TACK, SET 1.2 FEET BELOW GRADE, IN STANDARD KC MON. CASE.  
ELEVATION = 367.06

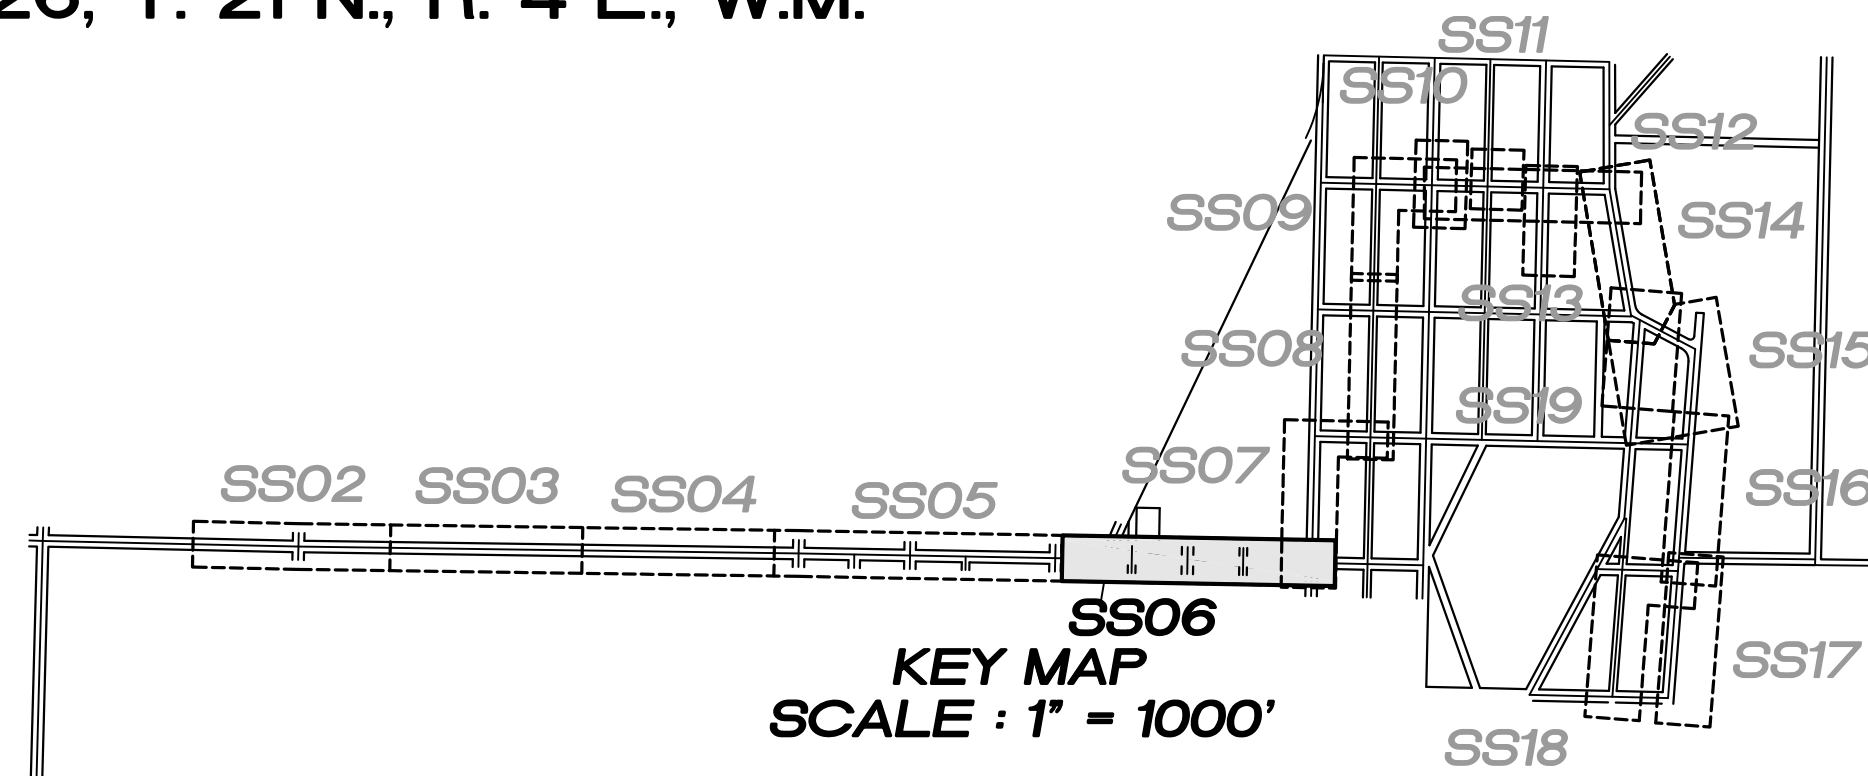

LAKEHAVEN UTILITY DISTRICT

0 Water Plan      8 Sewer Plan

Dated \_\_\_\_\_

APPROVED FOR CONSTRUCTION  
SUBJECT TO CHANGES NOTED

The District's review is not a check of any dimension or quantities and will not relieve the Developer from responsibility for errors of any sort. No changes shall be made in the plans except by the consent of the District.


General Manager/District Engineer \_\_\_\_\_ Date \_\_\_\_\_

This construction plan will expire one year from plan approval date, if construction has not commenced.



15445 53RD AVE. S.  
SEATTLE, WA 98188  
PHONE: (206) 431-7970  
FAX: (206) 388-1648  
WEB SITE: PACENG.COM


Pacific Engineering Design, LLC  
Civil Engineering and Planning Consultants

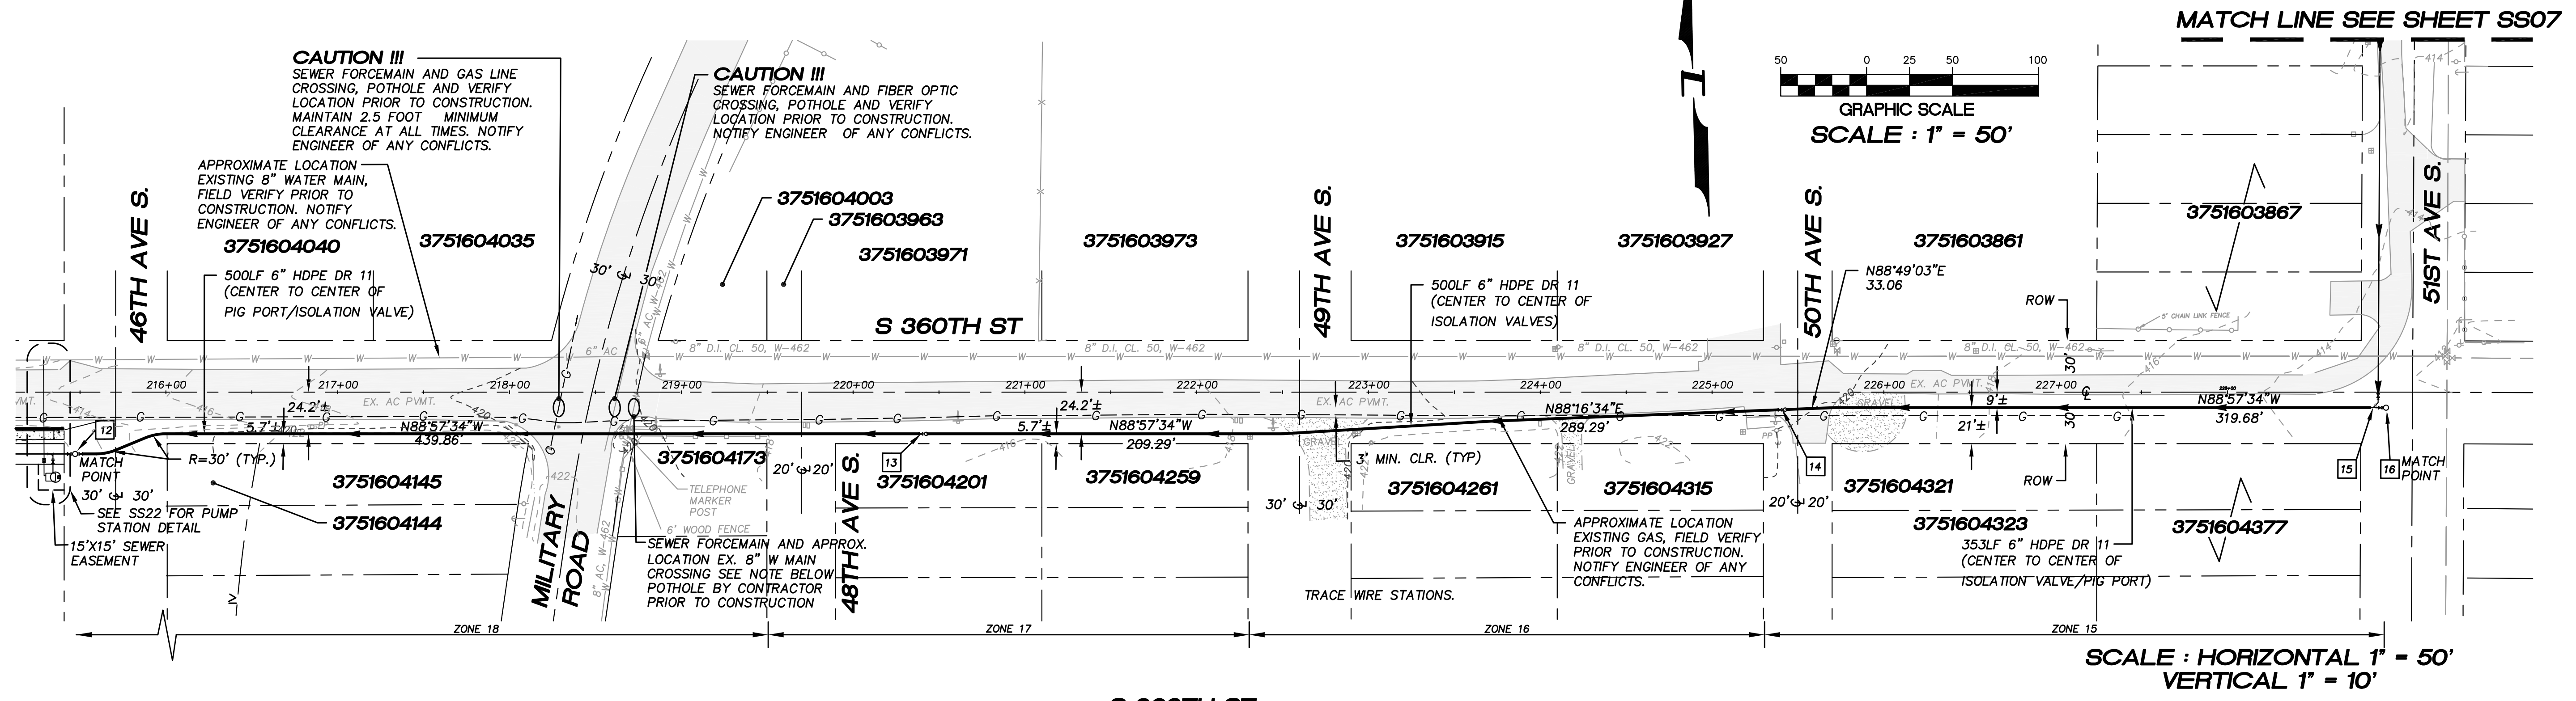

SCALE: HORIZONTAL 1" = 50'  
VERTICAL 1" = 10'

**NOTES :**

- THE MINIMUM SEPARATION BETWEEN (PARALLEL PIPELINES) WATER MAIN, WATER SERVICE LINE AND PRESSURE SEWER FACILITIES (MUST BE BELOW WATER MAIN OR WATER SERVICE) MUST BE MET, ARE AS FOLLOWS:  
HORIZONTAL  $\geq 10'$  MEASURED EDGE TO EDGE VERTICAL  $\geq 18"$ , MEASURED EDGE TO EDGE.
- THE MINIMUM SEPARATION BETWEEN (CROSSING PIPELINES) WATER MAIN, WATER SERVICE LINE AND PRESSURE SEWER FACILITIES (MUST BE BELOW WATER MAIN OR WATER SERVICE) MUST BE MET, ARE AS FOLLOWS:  
HORIZONTAL  $\geq 10'$  MEASURED EDGE TO EDGE VERTICAL  $\geq 18"$ , MEASURED EDGE TO EDGE.
- IF THE EXISTING WATER IS AC PIPE, IT SHALL BE REPLACED WITH SAME SIZE DUCTILE IRON PIPE 10 FEET EACH SIDE OF SEWER CROSSING BUT NO LESS THAN 2 FEET INTO BOTH TRENCH WALLS (NO CDF CRADLE ALLOWED).
- LOCATION OF EXISTING UNDERGROUND UTILITIES WAS PROVIDED BY UTILITY LOCATE AND BY AS BUILT RECORDS. UTILITY PAINT MARKS WERE FIELD SURVEYED BY CES NW INC.
- OTHER UTILITY SEPARATION BETWEEN PRESSURE SEWER FACILITIES MUST BE MET, ARE AS FOLLOWS:  
HORIZONTAL  $\geq 3'$  MEASURED EDGE TO EDGE VERTICAL  $\geq 6"$ , MEASURED EDGE TO EDGE.
- FOR PARCELS IN PEPPER HILL ESTATES AREAS, EXISTING PARCEL NUMBERS AND LOT NUMBERS WILL BE UPDATED AFTER BOUNDARY LINE ADJUSTMENTS ARE RECORDED.
- ALL CLEANOUTS W/PIG PORTS ARE USED AS TRACER WIRE STATIONS.
- FRAMES AND COVERS FOR CLEANOUTS/PIGPORTS NOT SUBJECT TO VEHICULAR TRAFFIC SHALL BE SET 6" ABOVE FINISHED GRADE AND BE PROTECTED BY VALVE BOX PROTECTIVE PADS.

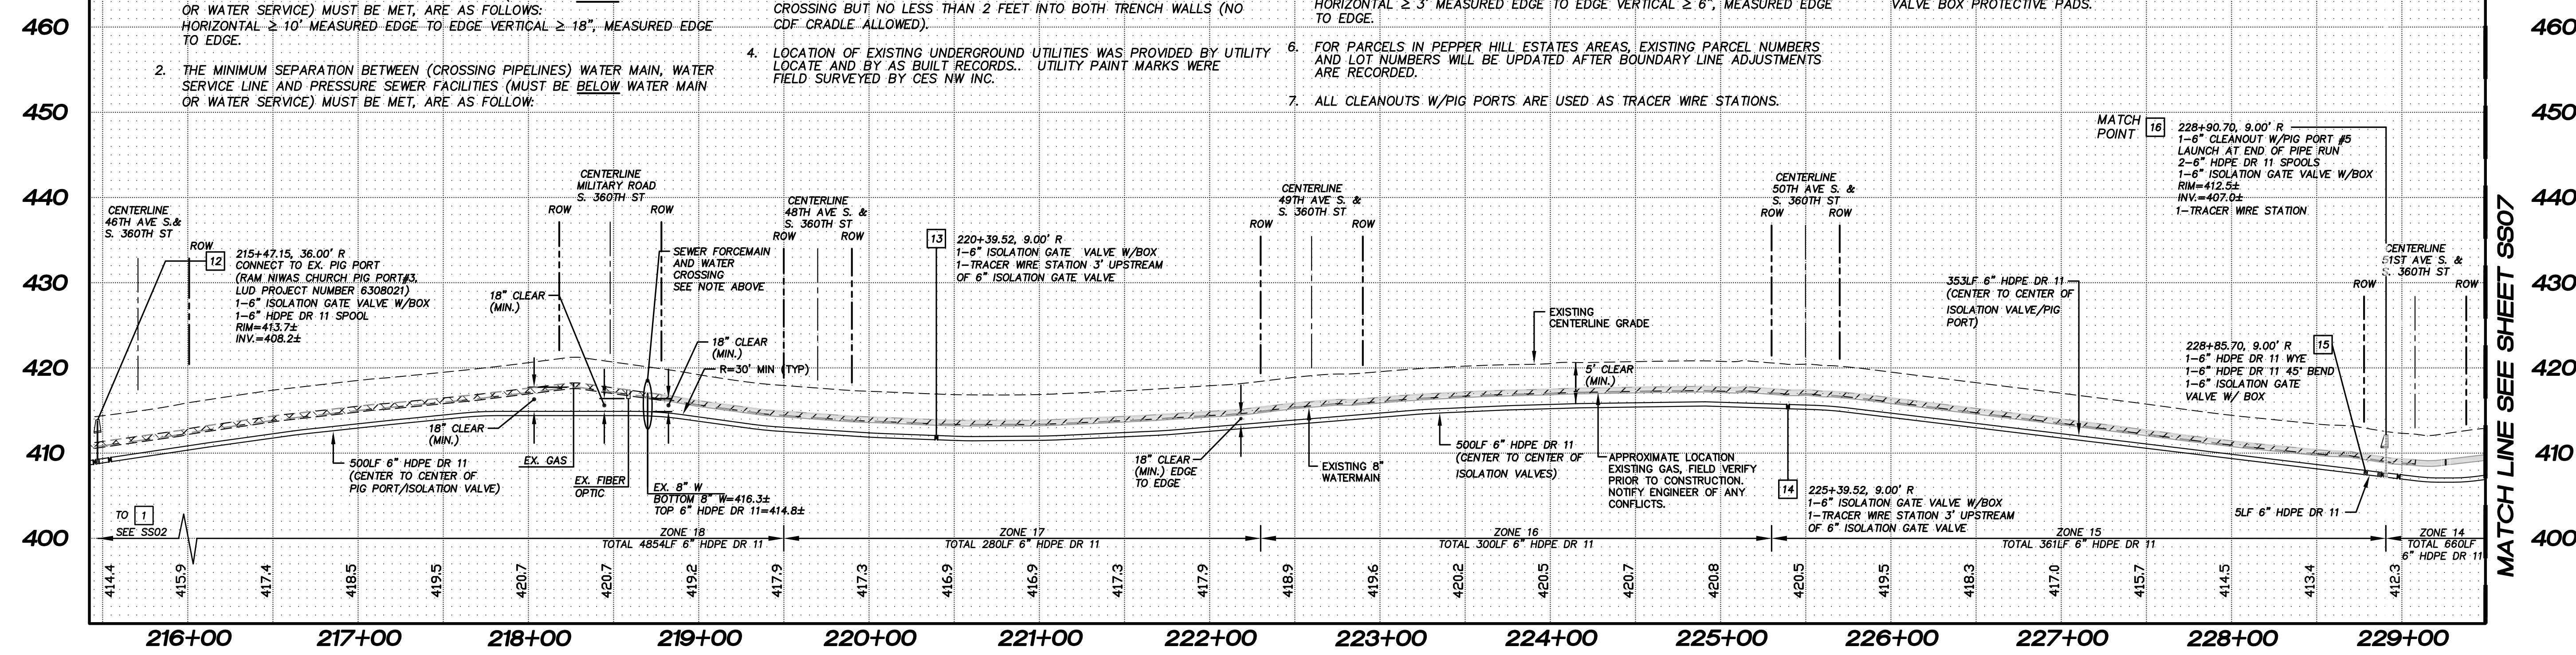

LAKEHAVEN UTILITY DISTRICT PROJECT No. 6304025  
PEPPER HILL ESTATES  
KING COUNTY, WA

FOR: PACIFIC HOUSING GROUP I, LLC  
SEATTLE, WA 98107-1346  
PHONE: (206) 521-5979 FAX: (206) 224-2880

PROJECT NO.: 05052  
DRAWN BY: JGC  
ISSUE DATE: 09-30-05  
SHEET REV.: 10-17-11

FORCE MAIN  
SANITARY SEWER  
S 360TH ST  
STA. 215+47.15 TO  
STA. 228+90.70  
PLAN AND PROFILE

05052SS06.DWG  
**SS06**