


REVISIONS:

PORTION OF N.E. 1/4 S.W. 1/4 SEC. 34, T. 24N., R. 5 E., W.M.

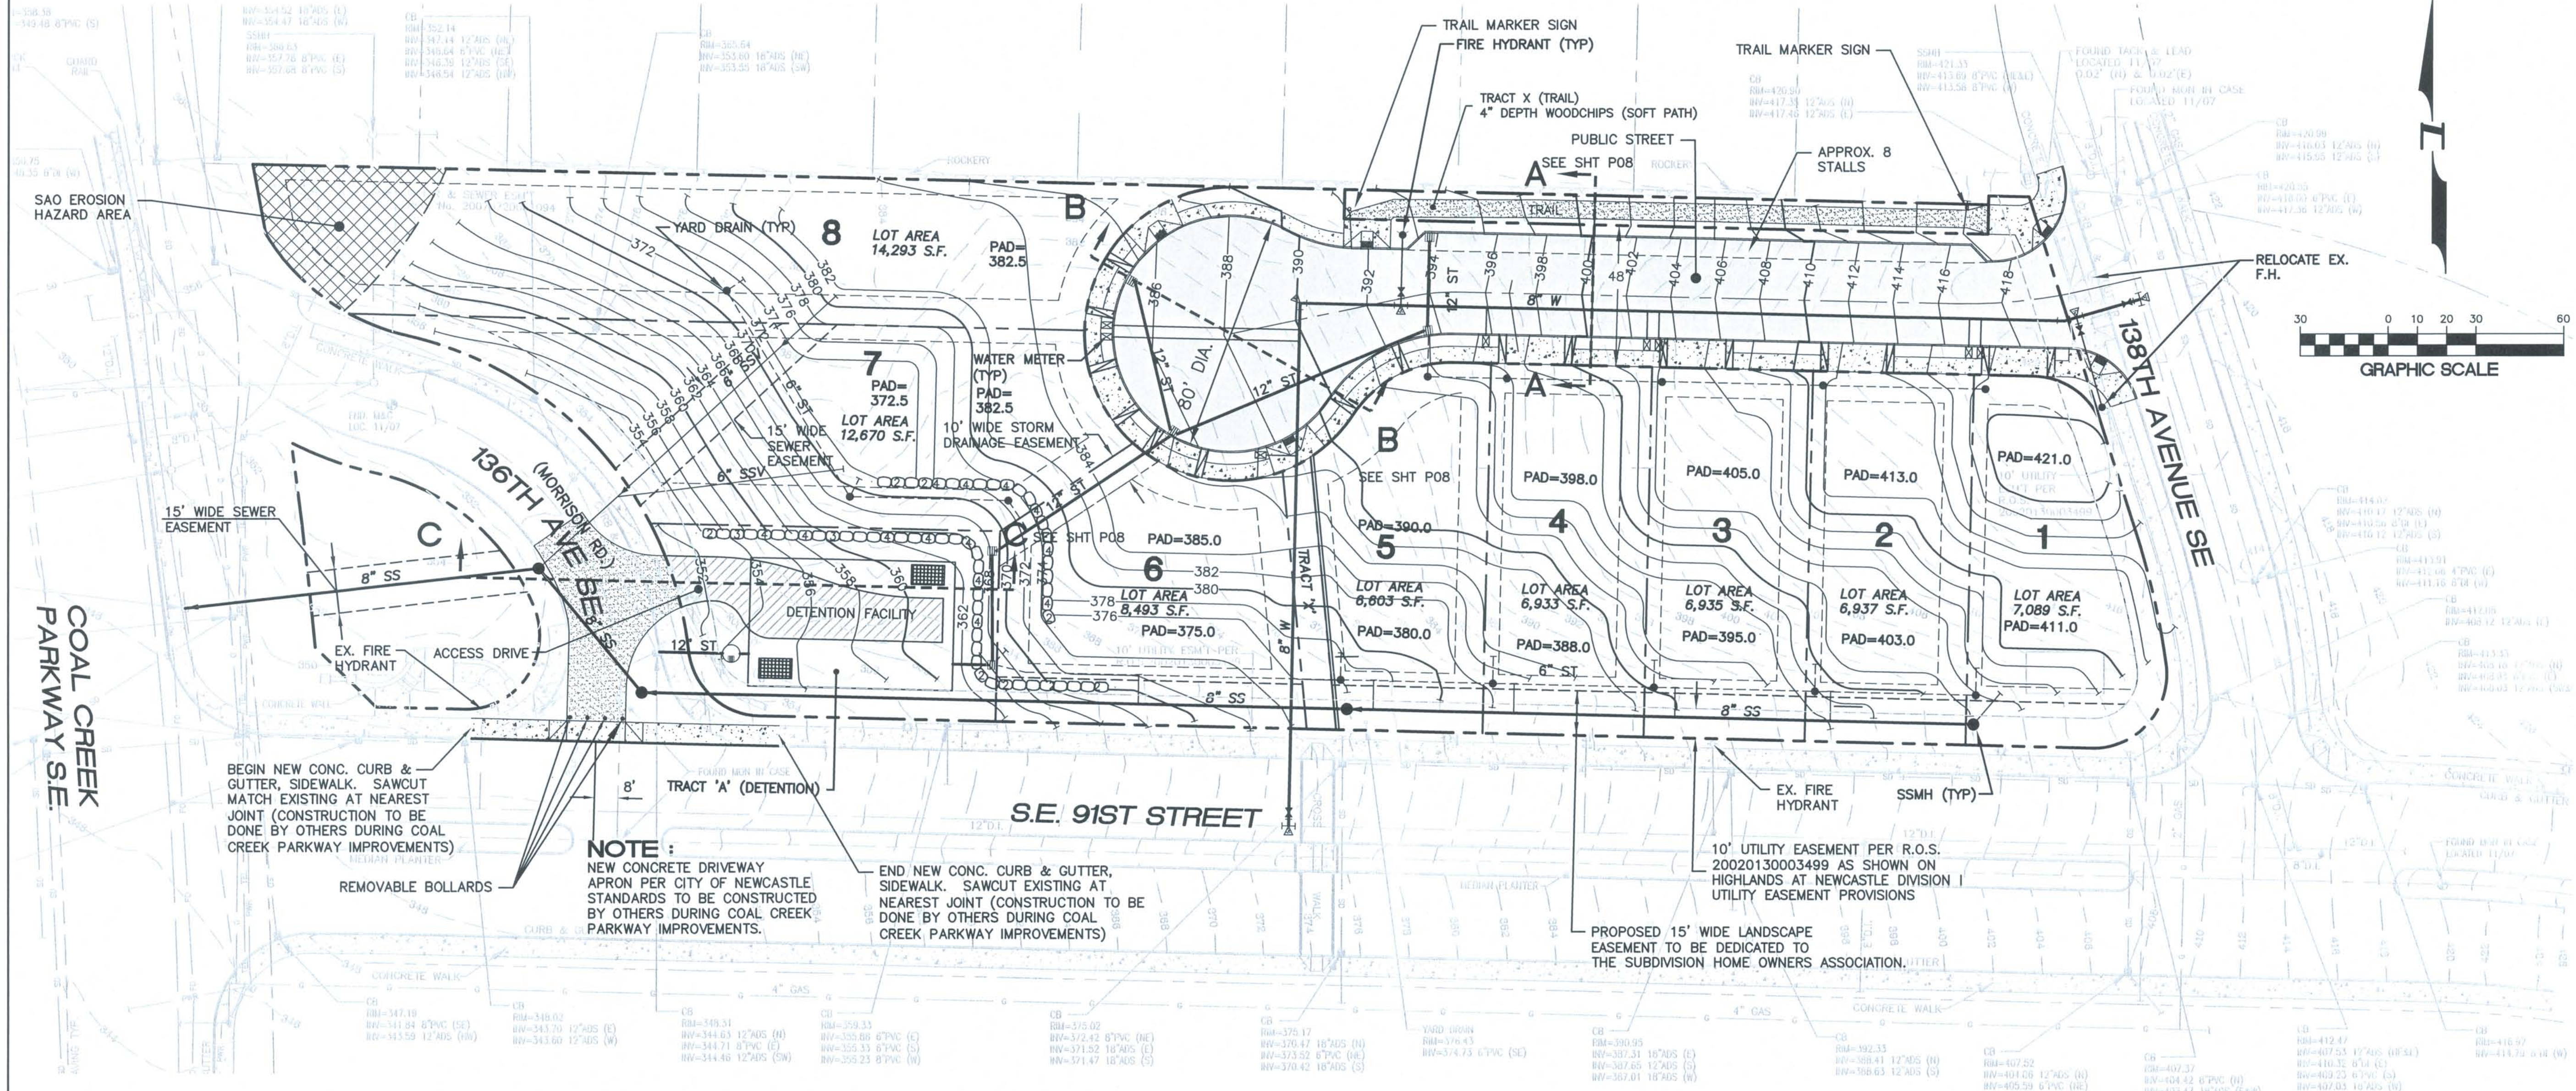

15445 53RD AVE. S.
SEATTLE, WA 98188
PHONE: (206) 431-7970
FAX: (206) 388-1648
WEB SITE: PACEING.COM

Pacific
Engineering
Design, LLC
Civil Engineering and
Planning Consultants

TRACT 'J' SUBDIVISION
CITY OF NEWCASTLE

FOR:
THE HIGHLANDS AT NEWCASTLE, LLC
282 NORTHUP WAY, SUITE 100
BELLEVUE, WA 98004-1447
PHONE: (425) 739-3890
FAX: (425) 827-0462

PROJECT NO.: 07052
DRAWN BY: CJB
ISSUE DATE: 07-02-08
SHEET REV.: 02-04-09

PRELIMINARY
COMPOSITE
UTILITY AND
GRADING PLAN

P04

LEGEND

UTILITY PLANS		EXISTING FEATURES	
---	BOUNDARY / R.O.W. LINE	---SD---	EXISTING STORM DRAIN PIPE
---	CENTERLINE	---SS---	EXISTING SEWER MAIN
---	LOT LINE	---	EXISTING WATER MAIN
---	RIGHT-OF-WAY	---	EXISTING POWER LINE
---	GUTTER, FLOW, & CURB LINE	---	EXISTING GAS MAIN
---	STORM DRAIN PIPE	---	EXISTING CATCH BASIN, TYPE I
---	EASEMENT LINE	---	EXISTING CATCH BASIN, TYPE II
---	BUILDING SETBACK LINE (BSBL)	---	EXISTING SEWER MANHOLE
---	ROOF & FOOTING DRAIN	---	EXISTING LIGHT POLE
---	ROCKERY DRAIN	---	EXISTING POWER VAULT
---	8" SS SEWER MAIN	---	EXISTING GUY ANCHOR
---	8" WTR SEWER SERVICE	---	EXISTING WATER METER
---	8" WTR WATER MAIN	---	EXISTING FIRE HYDRANT
---	10' EXISTING CONTOURS	---	EXISTING AIR/VAC RELEASE VALVE
---	2' EXISTING CONTOURS	---	EXISTING BLOW OFF
---	10' PROPOSED CONTOURS	---	EXISTING GATE VALVE
---	2' PROPOSED CONTOURS	---	EXISTING CONIFEROUS TREE
---	SILT FENCE	---	EXISTING DECIDUOUS TREE
---	SWALE OR DITCH	---	
---	CATCHBASIN (TYPE I)		
---	CATCHBASIN (TYPE II)		
---	STORM CLEANOUT		
---	SEWER MANHOLE		
---	SEWER CLEANOUT		
---	SINGLE WATER METER		
---	DOUBLE WATER METER		
---	FIRE HYDRANT		
---	GATE VALVE		
---	TEE		
---	BEND		
---	CONCRETE BLOCKING		
---	ROCKERY		
---	SIGN		
---	CURB RAMP		
---	PROPOSED ASPHALT PAVEMENT		
---	PROPOSED SIDEWALK		