
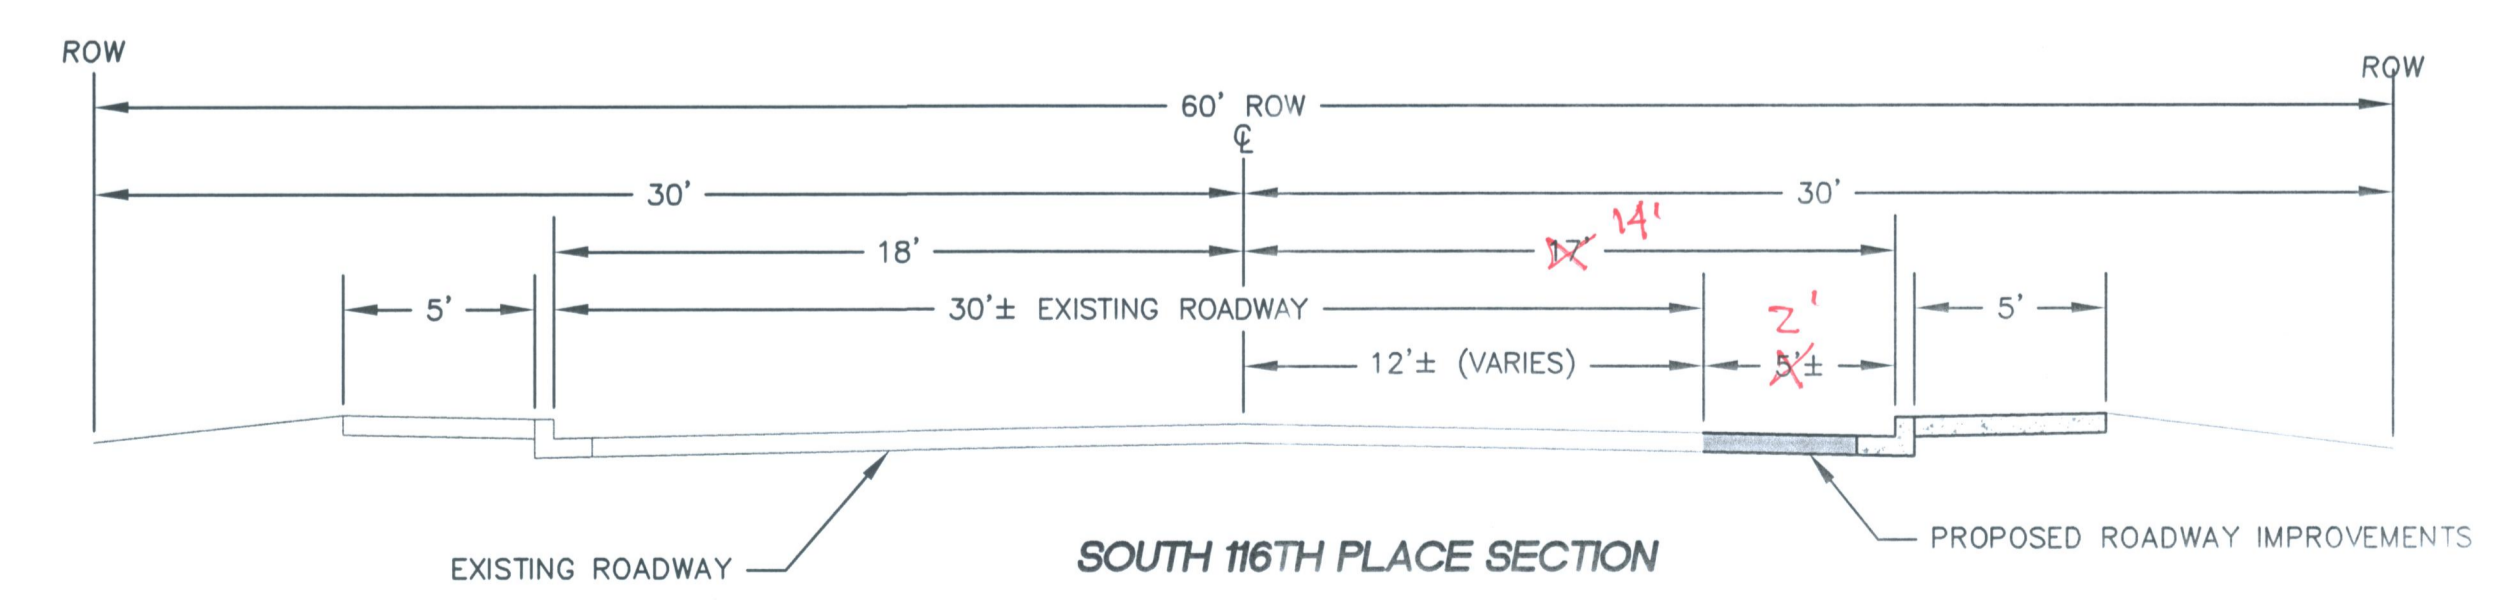
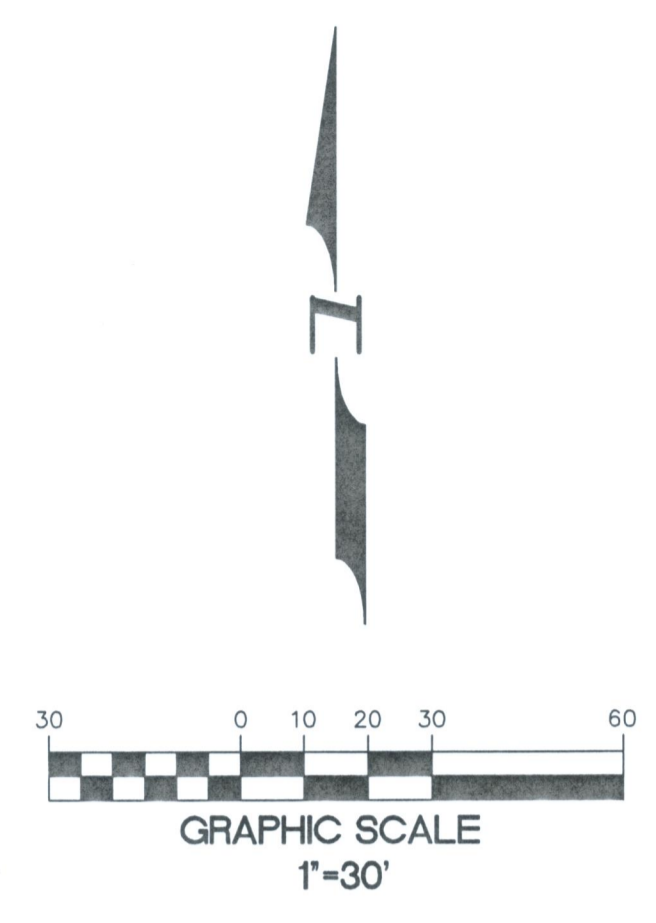


10/29/2010 09:37:49 10018801

REVISIONS:

THE SW CORNER OF THE SW 1/4, NW 1/4, SEC. 12, TWP. 23 N., RGE. 04 E., W.M.

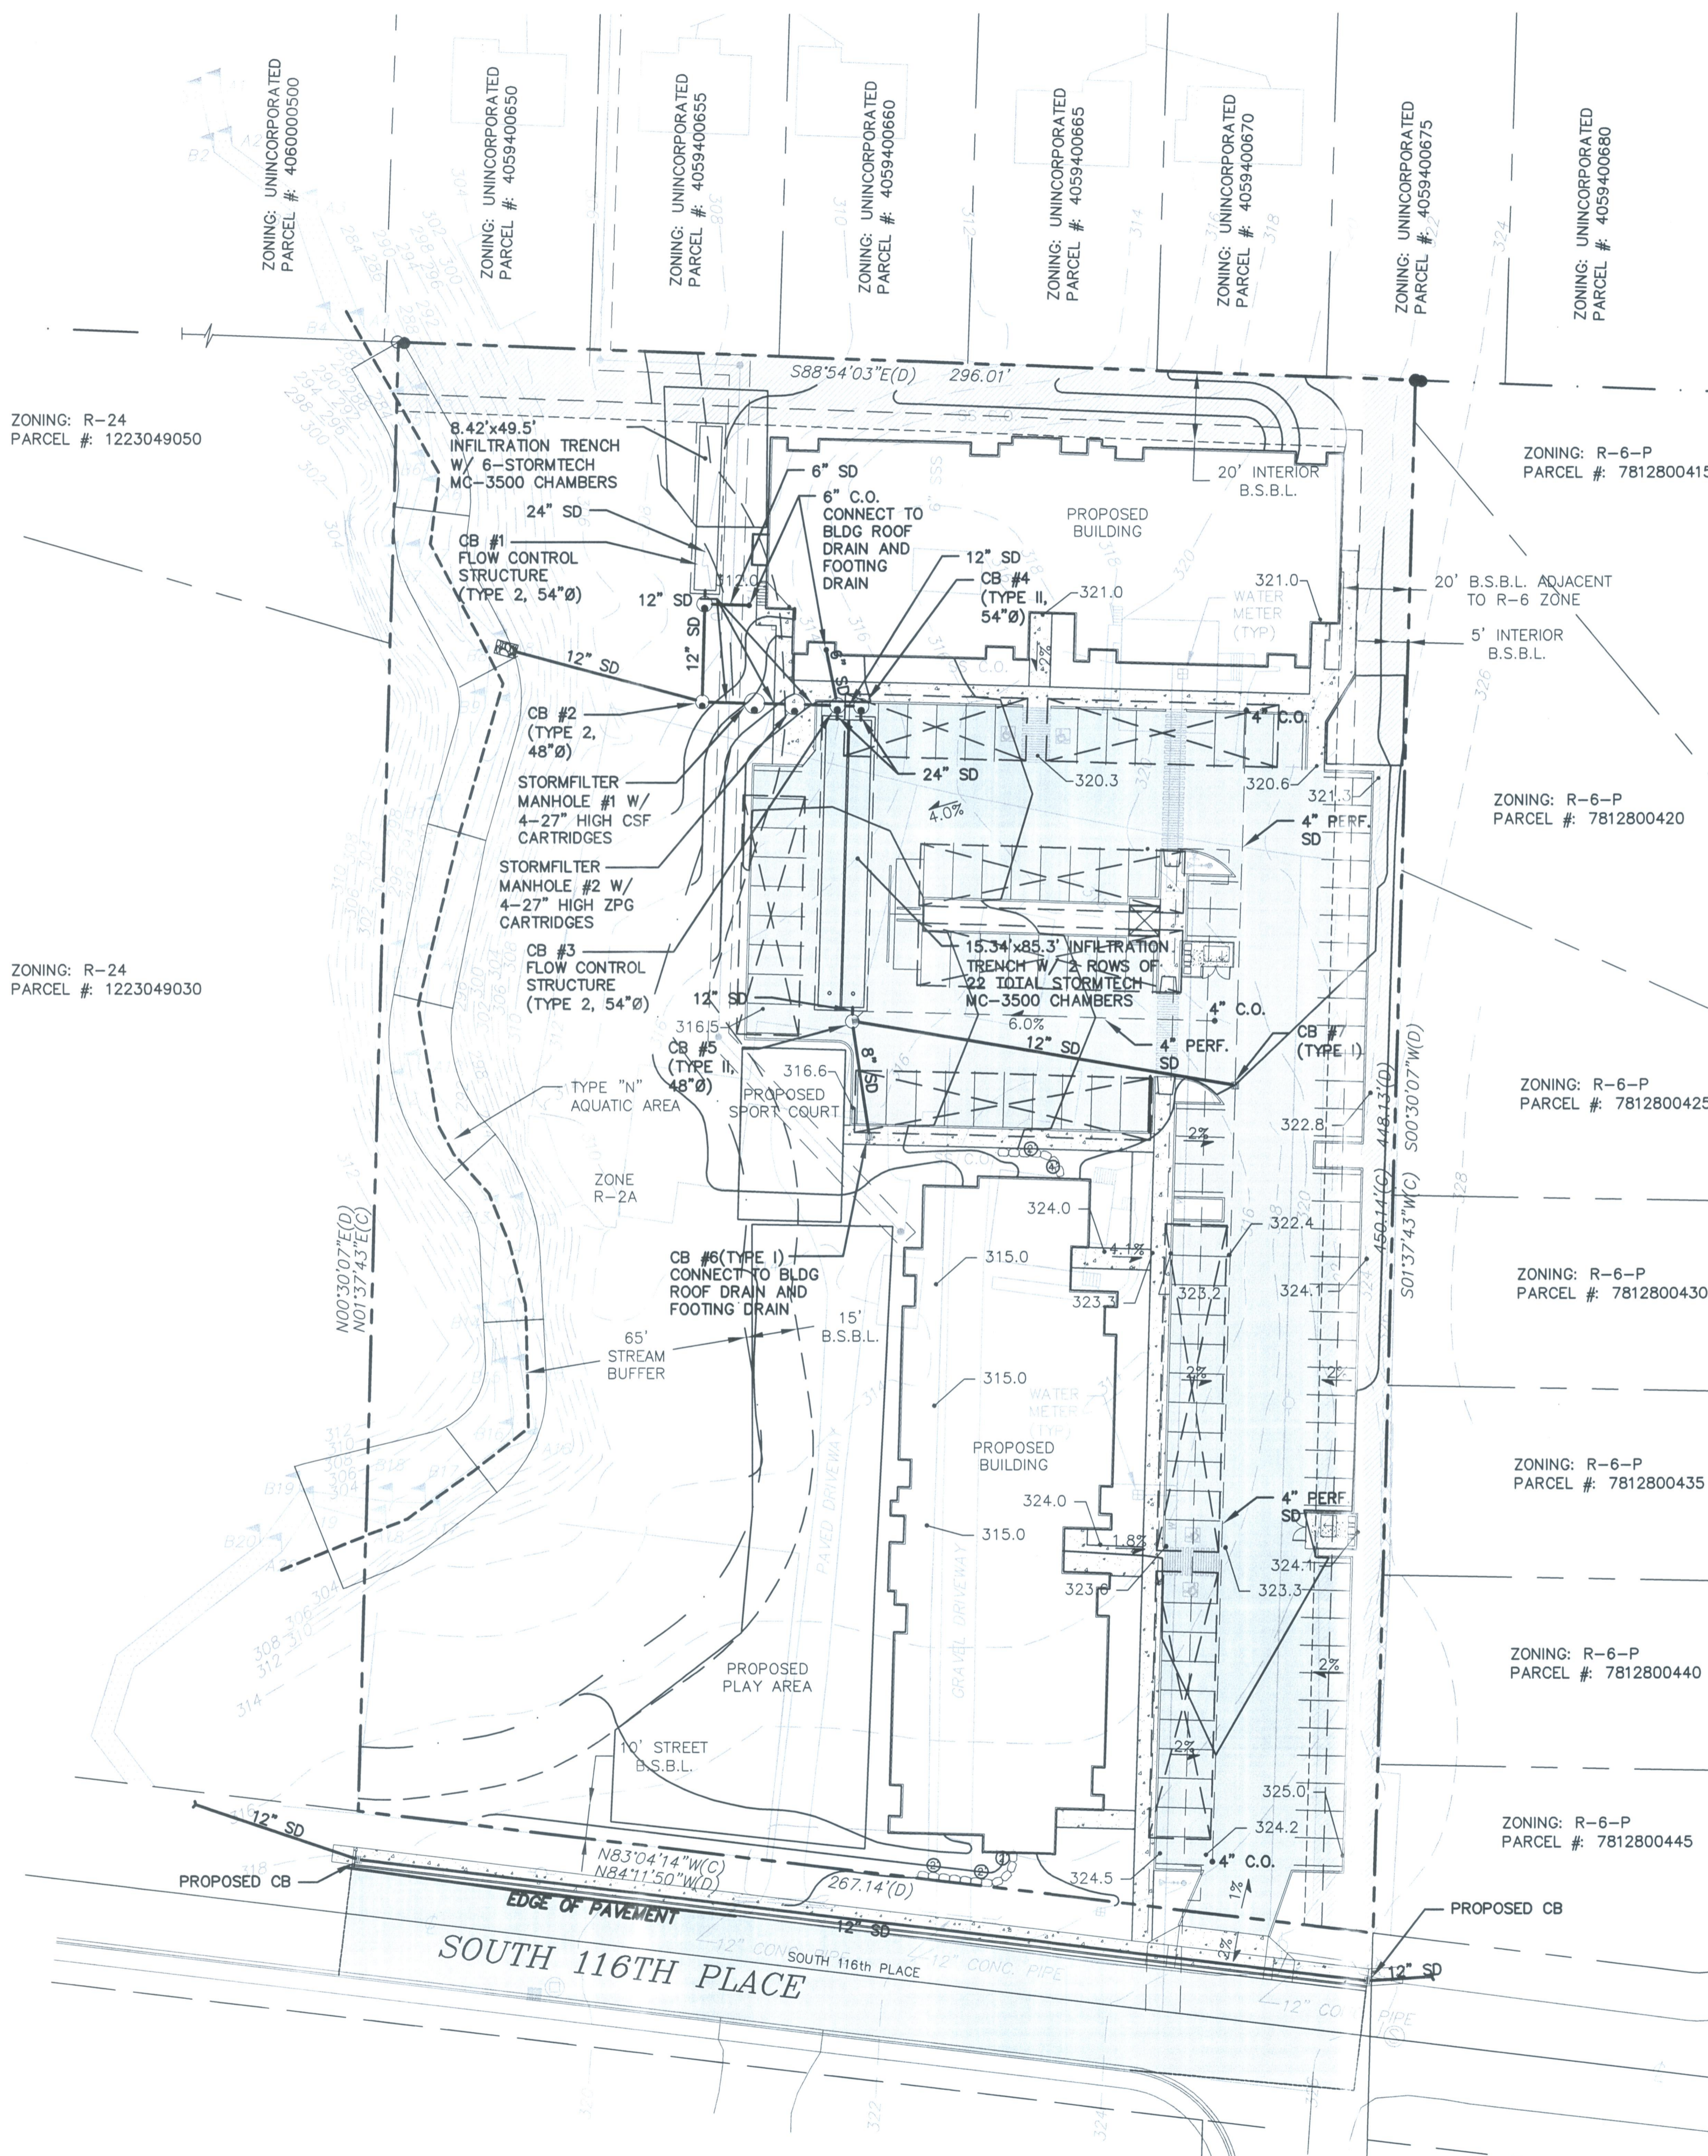

Pacific Engineering
Design, LLC
 Civil Engineering & Planning Consultants

Phone: (206) 431-7970 Fax: (206) 388-1648
 15445 53RD Ave. S. Seattle, WA 98188 www.paceng.com

Taylor Creek Apartments
 KING COUNTY

RYAN GROUWS
 G3 INVESTMENTS, LLC
 P.O. BOX 78448
 SEATTLE, WA 98178
 Phone: (XXX) XXX-XXXX
 Fax: (XXX) XXX-XXXX

PROJECT NO.: 10018
 DRAWN BY: ENM
 ISSUE DATE: 2010-09-02
 SHEET REV.:

GRADING AND DRAINAGE PLAN

10018G01.DWG
C04
 SHEET 04 OF 05