
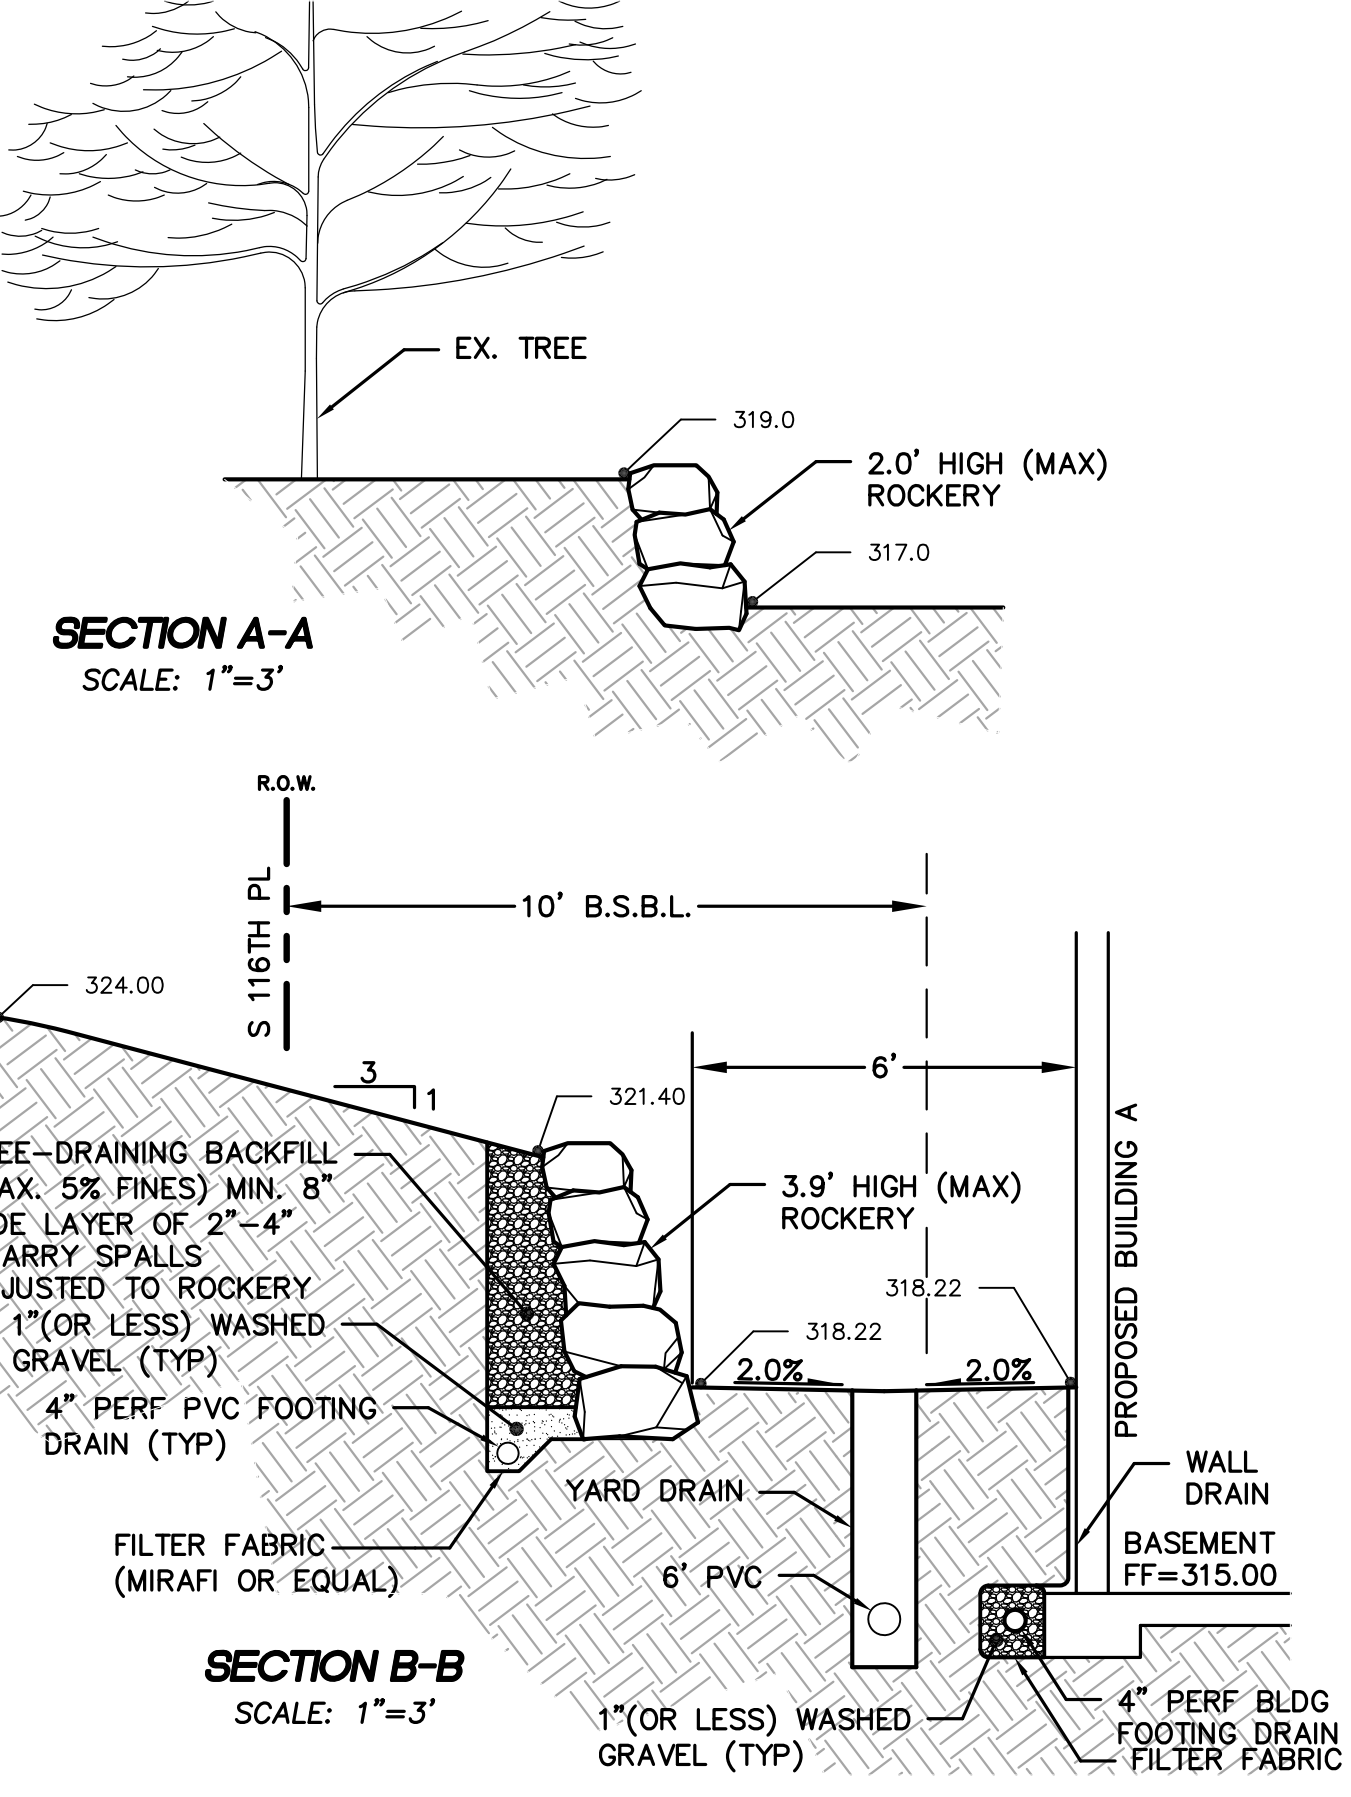
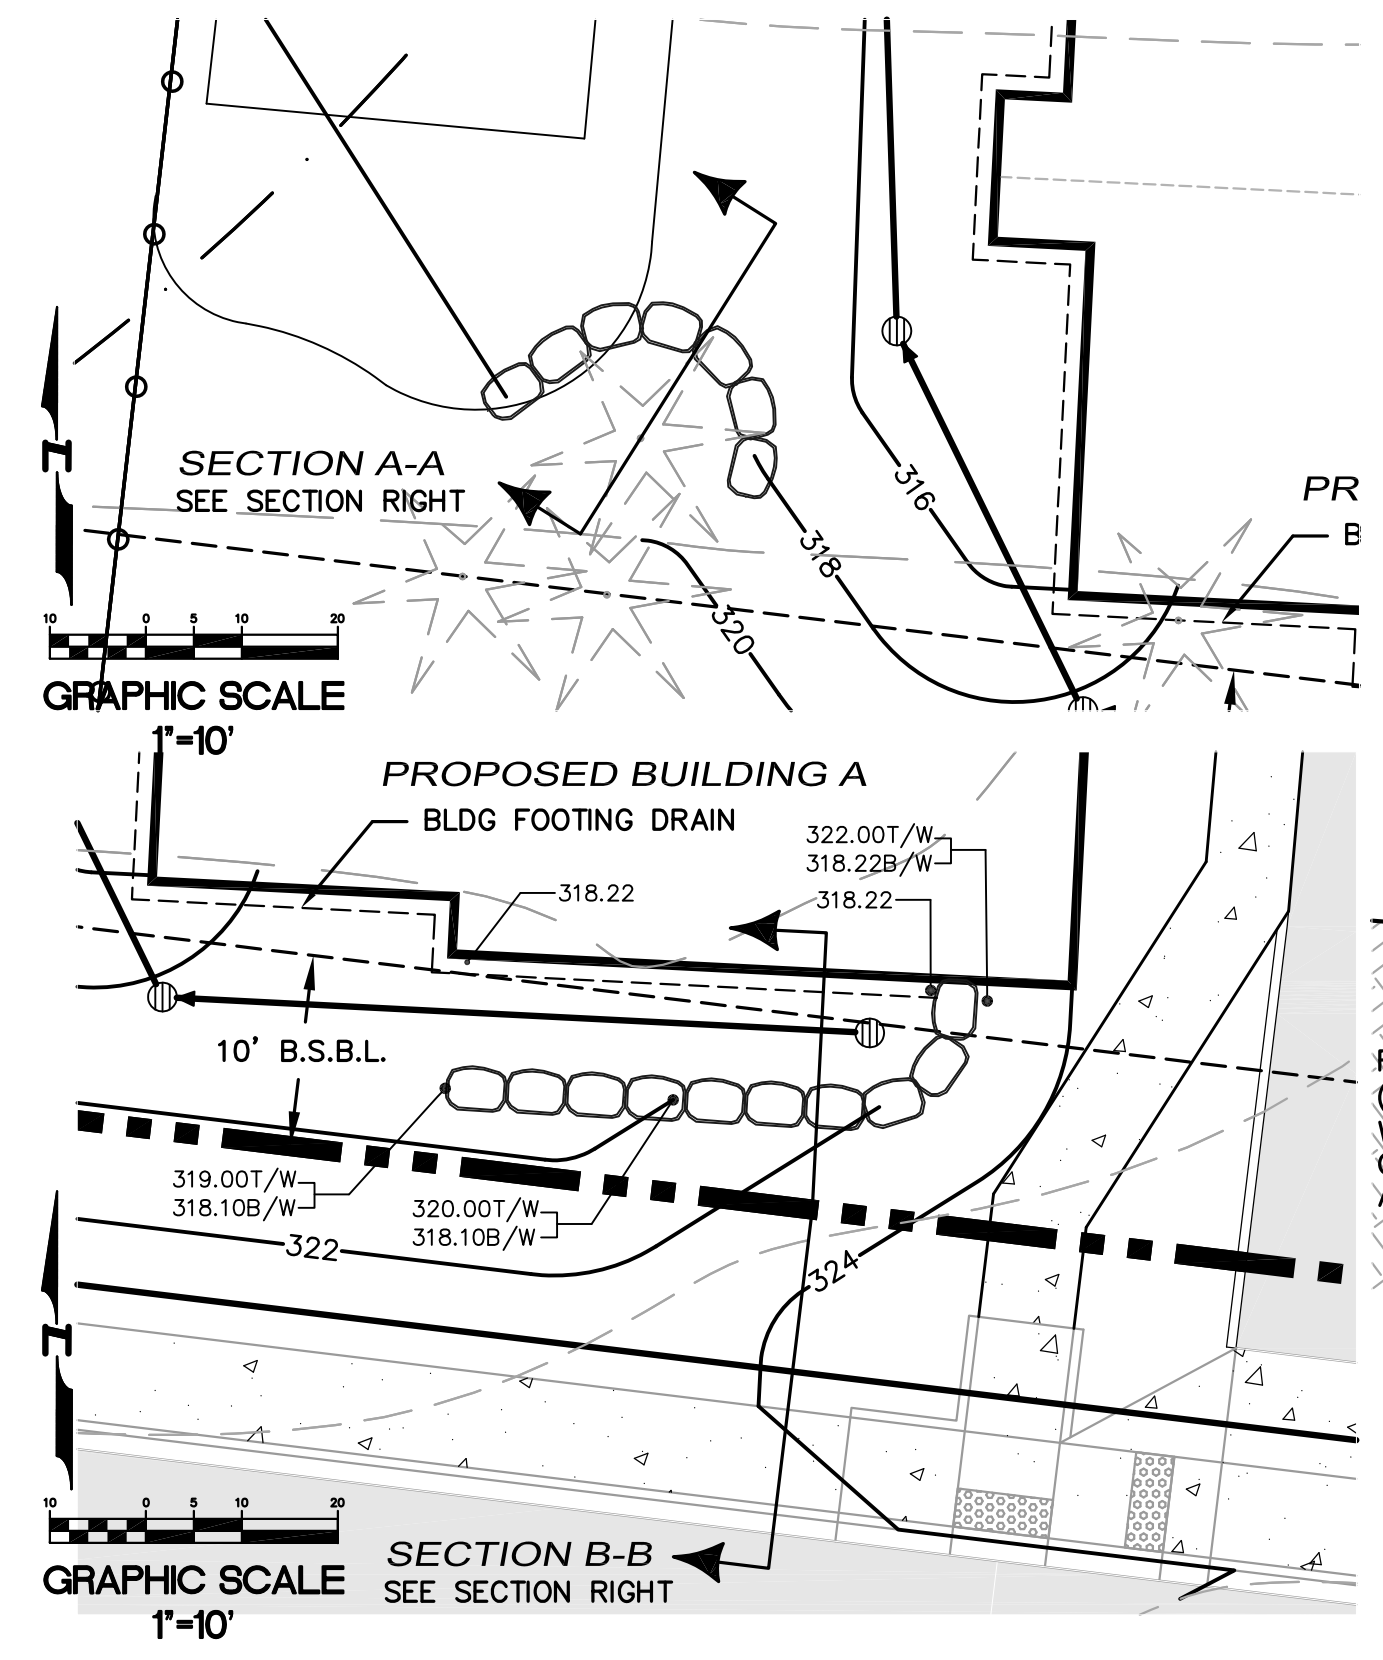


EARTHWORK VOLUMES:

CUT 2180 CY  
FILL 6710 CY

THE SW CORNER OF THE SW 1/4, NW 1/4, SEC. 12, TWP. 23 N., RGE. 04 E., W.M.

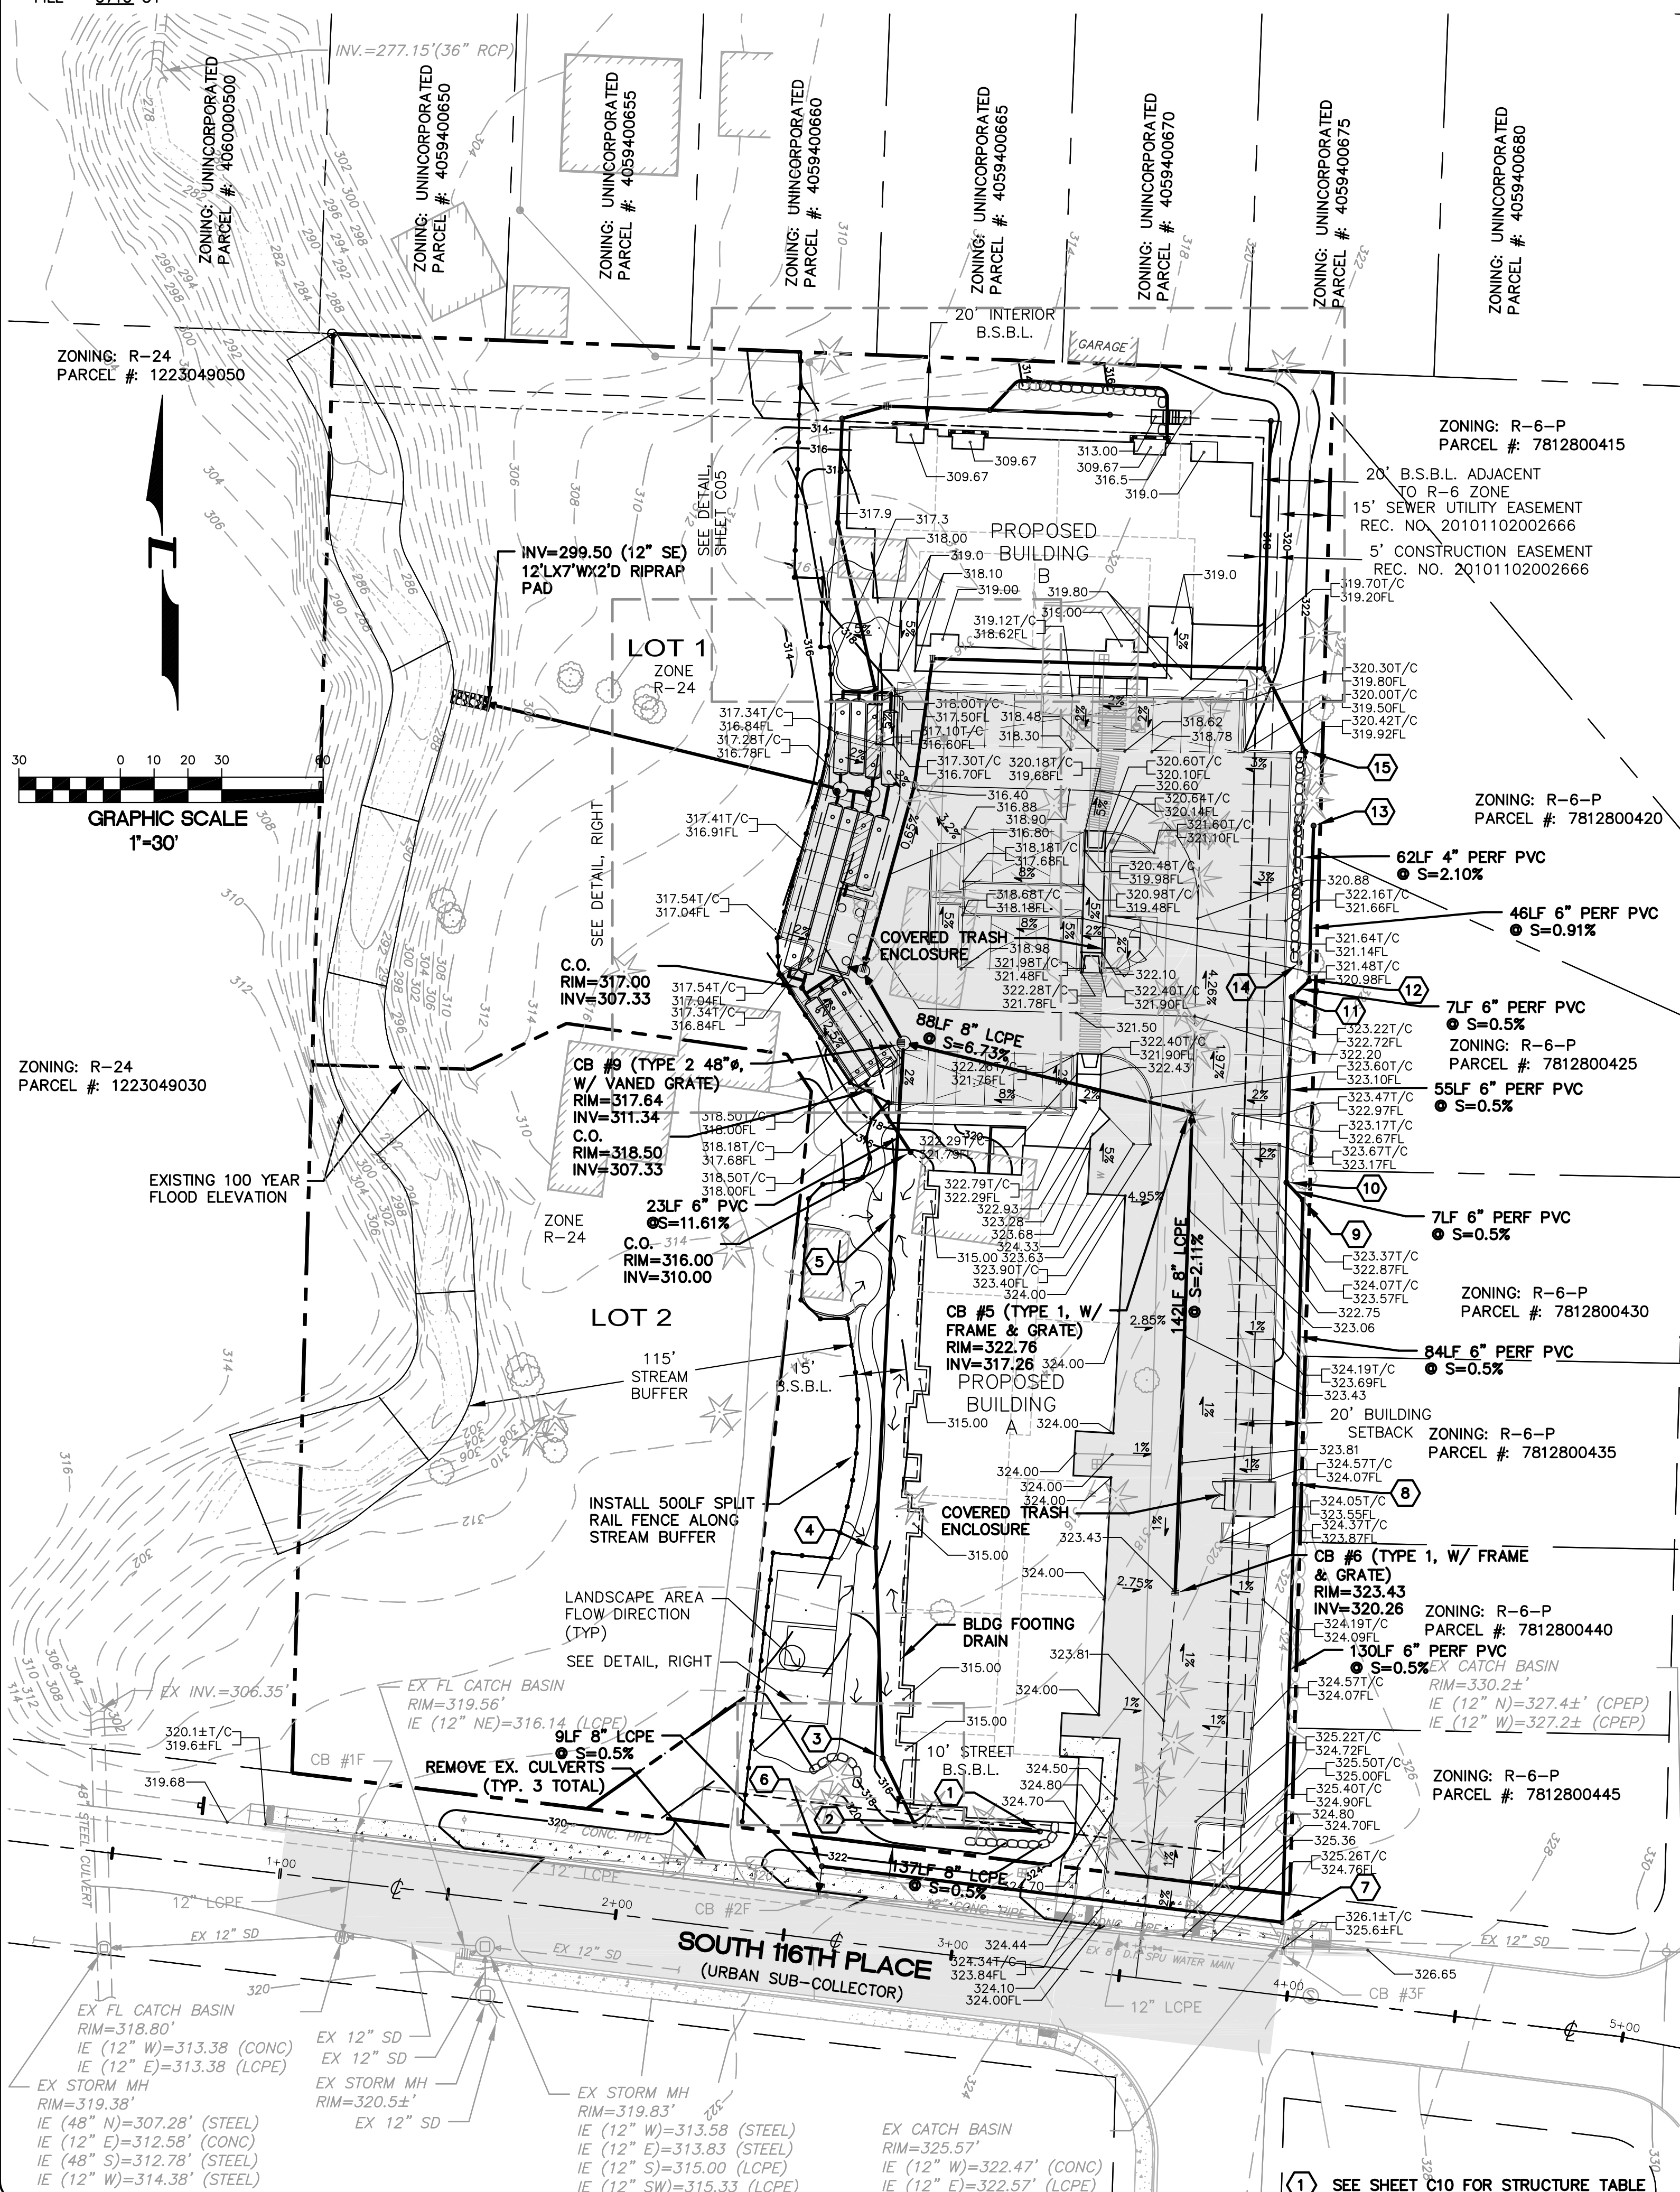

**Pacific Engineering Design, LLC**  
Civil Engineering & Planning Consultants

Phone: (206) 431-7970 Fax: (206) 388-1648  
15445 53RD Ave. S. Seattle, WA 98188 www.paceng.com

**Taylor Creek Apartments**  
KING COUNTY

RYAN GROUWS  
G3 INVESTMENTS, LLC  
P.O. BOX 78448  
SEATTLE, WA 98178  
Phone: (425) 255-5747  
Fax: (425) 255-4882

PROJECT NO.: 10018  
DRAWN BY: ENM  
ISSUE DATE: 2010-12-01  
SHEET REV.: 2012-07-26

GRADING AND DRAINAGE PLAN

10018GR01.DWG  
**C04**  
SHEET 04 OF 11