


SECOND FLOOR ELECTRICAL PLAN

SCALE: 1/8" = 1'-0"




| ELECTRICAL LEGEND | | | |
|-------------------|---|--|---|
| | LIGHT FIXTURE, WALL MOUNTED | | DUPLEX POWER OUTLET |
| | LIGHT FIXTURE, RECESSED CEILING MODIFIERS: wp - WATERPROOF FIXTURE | | MODIFIERS: wp - WATERPROOF OUTLET |
| | EMERGENCY LIGHT | | grca - GROUND FAULT CIRCUIT INTERRUPTER |
| | TRACK LIGHT | | 48" - MOUNTING HEIGHT A.F.F. |
| | FLOURESCENT LIGHT FIXTURE | | FLOOR MOUNTED DUPLEX POWER OUTLET |
| | EXHAUST FAN | | SWITCHED POWER OUTLET |
| | SWITCH MODIFIERS: 3 - 3-WAY 4 - 4-WAY d - DIMMER | | 220 VOLT OUTLET |
| | ELECTRICAL WIRING | | THERMOSTAT |
| | | | SMOKE DETECTOR |
| | | | TELEPHONE / DATA OUTLET |
| | | | CABLE TV OUTLET |

E400 E404 E408 E410 E420 E425 E430
 0126 0132 0135 0136 0139 B055

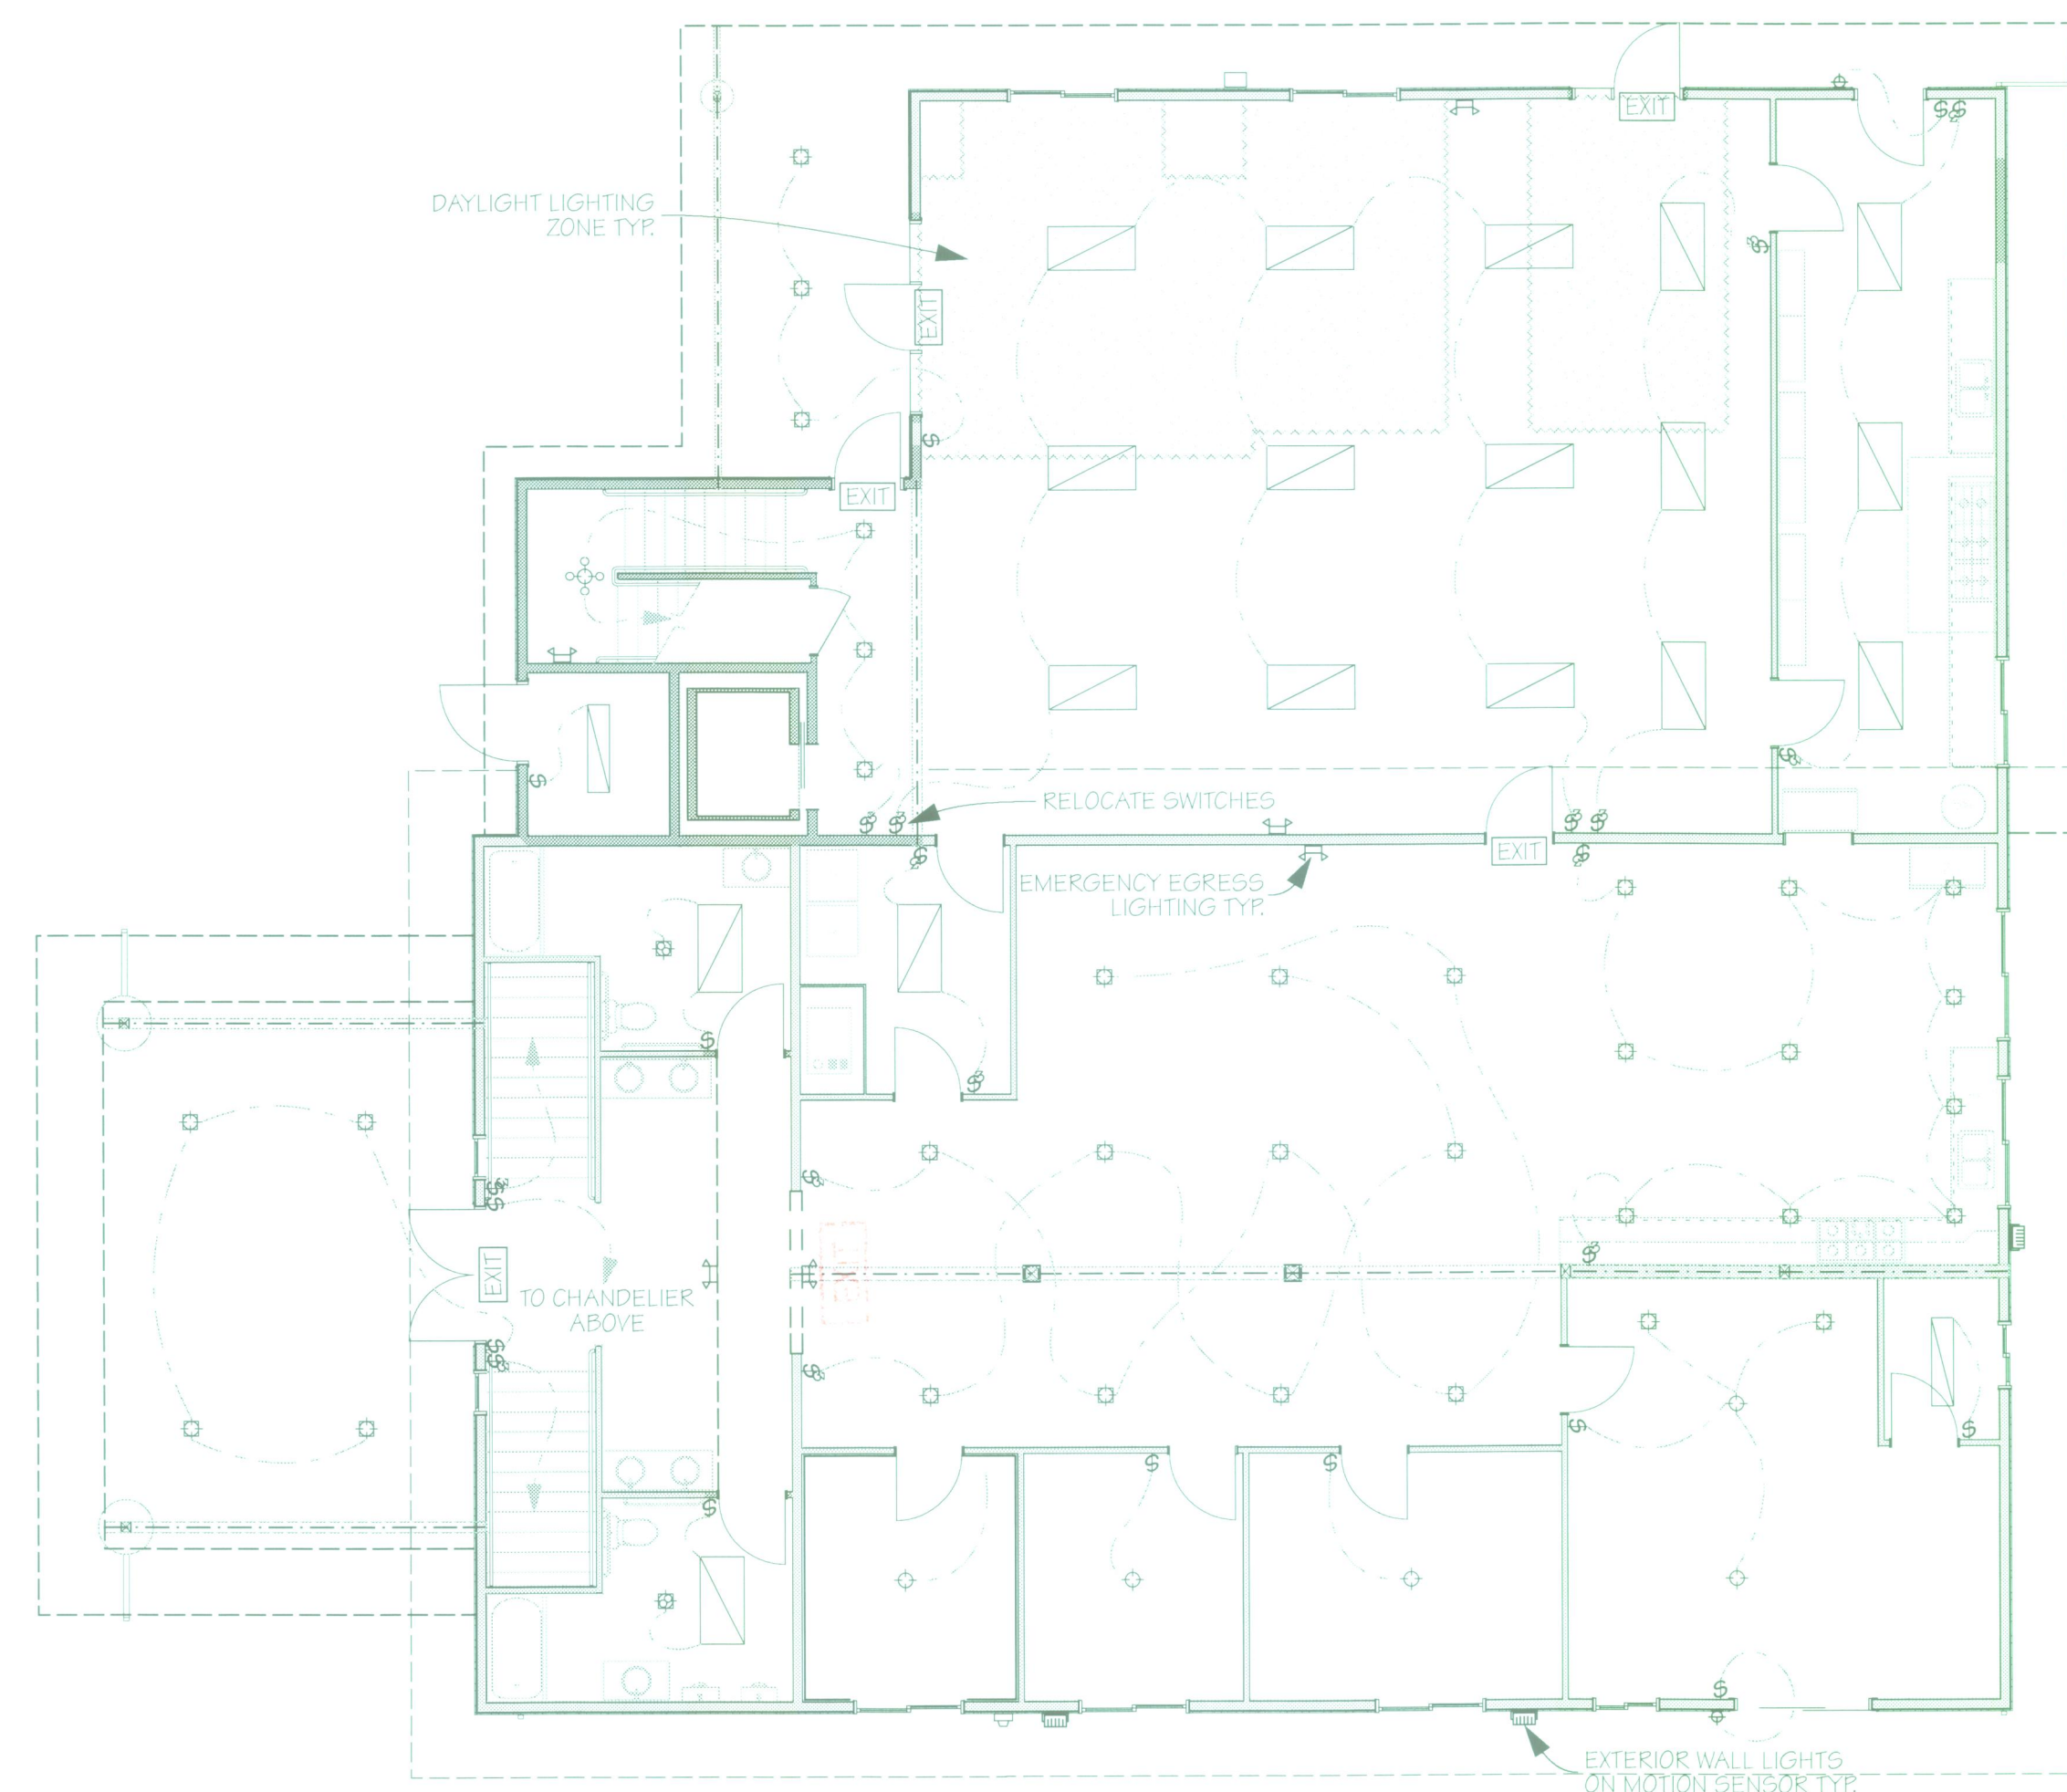


GROUND FLOOR ELECTRICAL PLAN

SCALE: 1/8" = 1'-0"

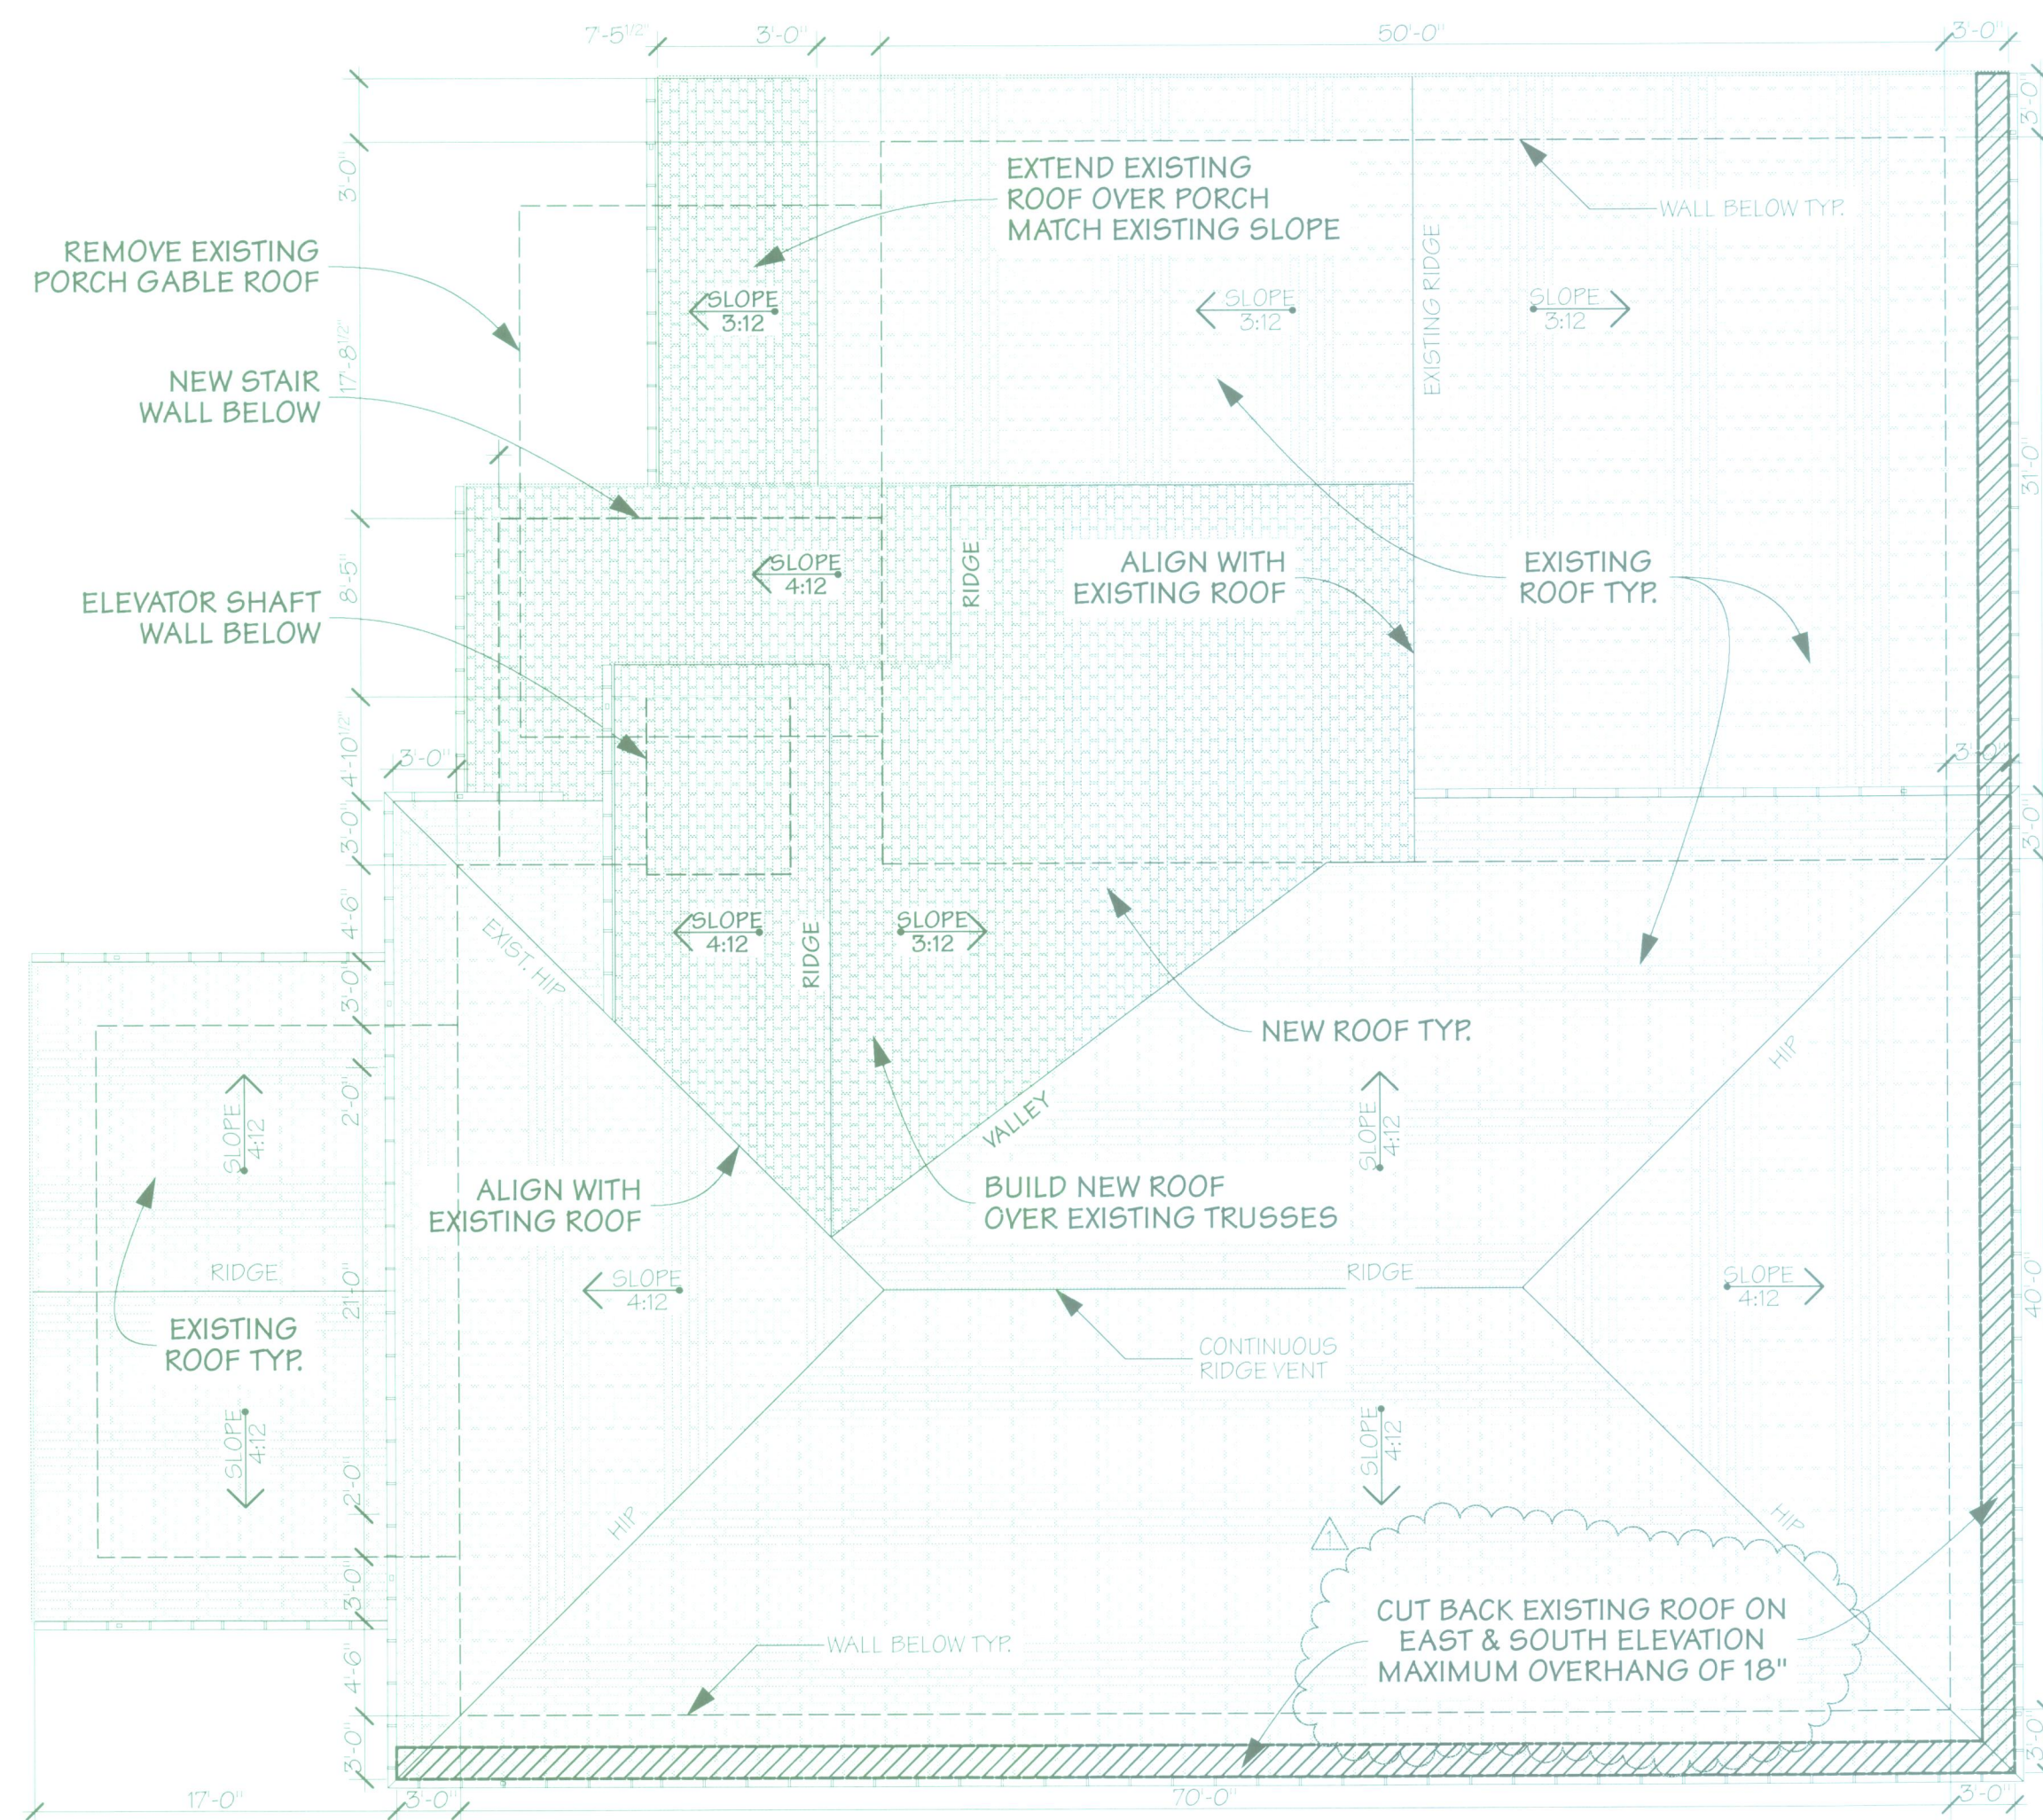

ROOF PLAN

SCALE: 1/8" = 1'-0"

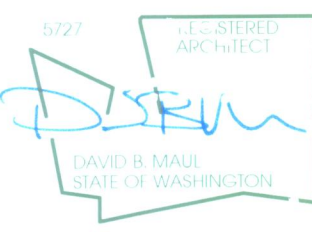

| | |
|----------------------|------------|
| Project #: | 1-1012 |
| Principal Architect: | DRIVE MAUL |
| Project Manager: | JILL |
| Permit Submission: | 20 OCT 10 |
| Permit Corrections: | 14 JAN 11 |
| Permit Corrections: | 8 AUG 11 |

REVISION