

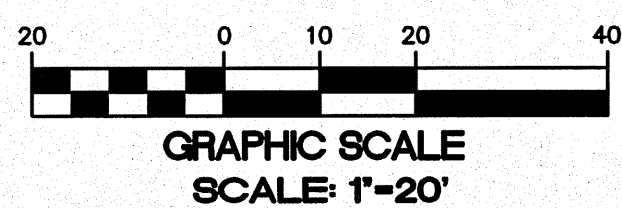


PORTION OF THE SW 1/4 OF THE NW 1/4 OF SEC. 33, TWN. 24N., RGE. 5E., W.M.

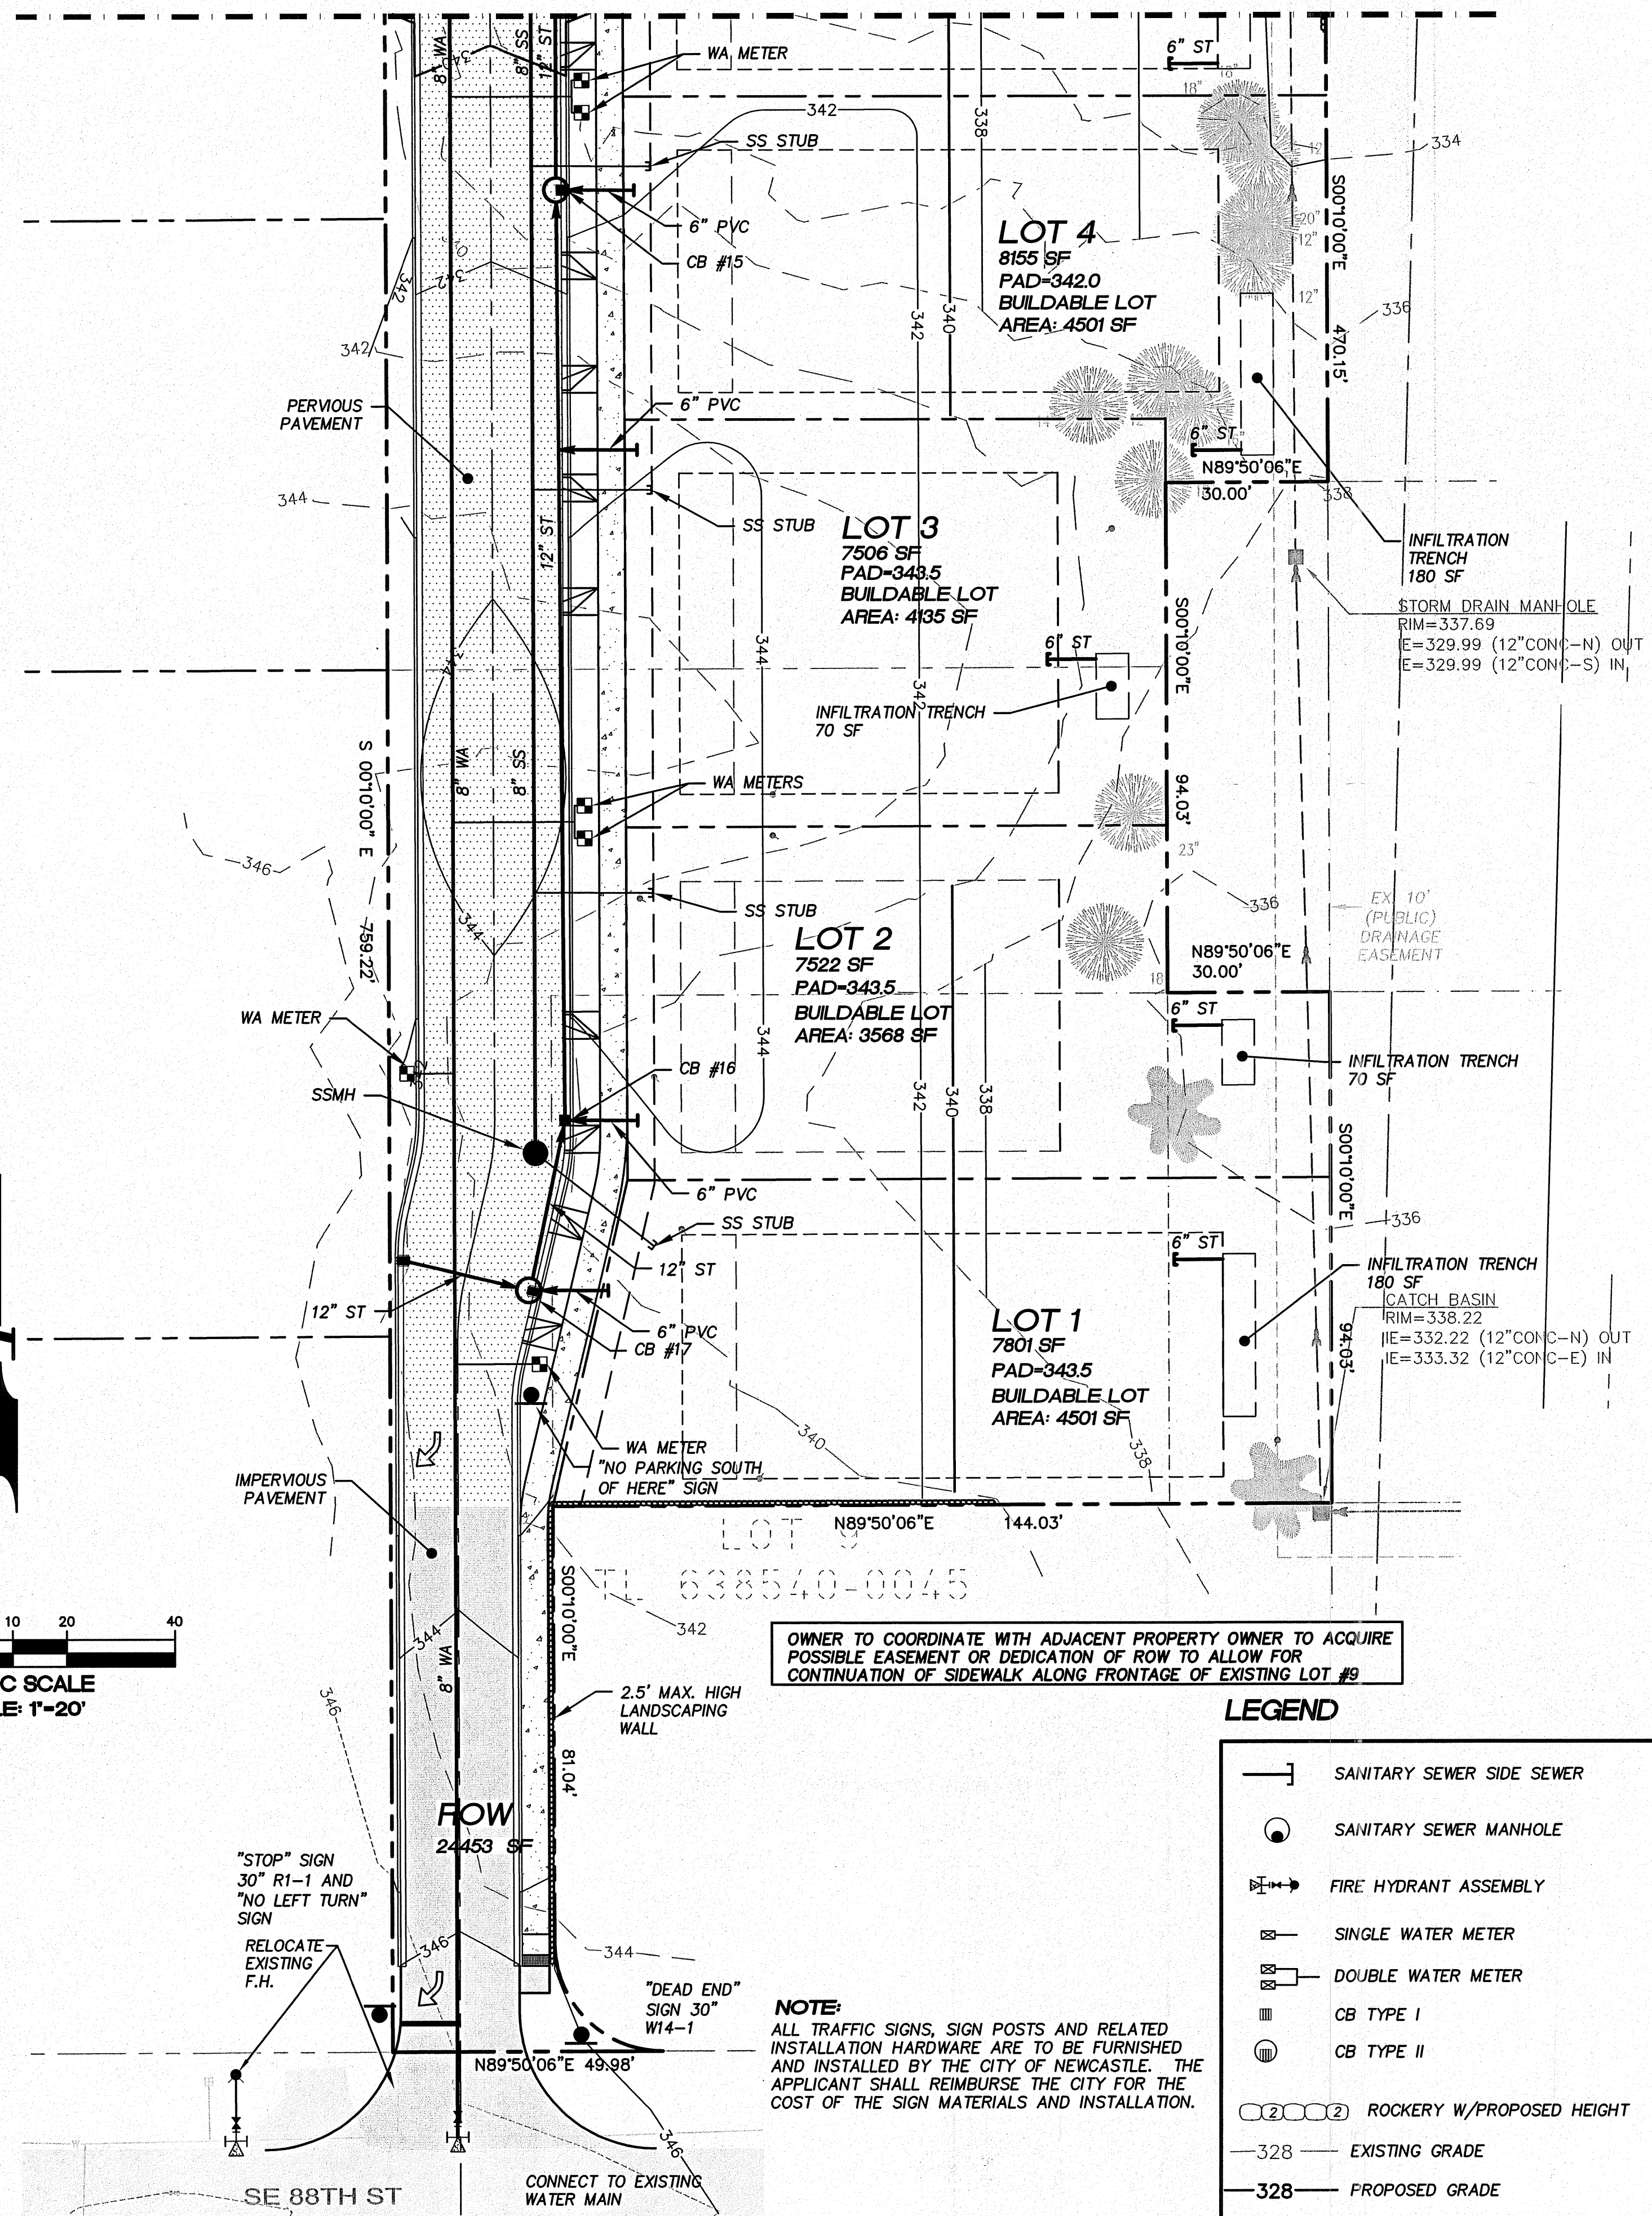

LEGEND

- SANITARY SEWER SIDE SEWER
- SANITARY SEWER MANHOLE
- FIRE HYDRANT ASSEMBLY
- SINGLE WATER METER
- DOUBLE WATER METER
- CB TYPE I
- CB TYPE II
- ROCKERY W/PROPOSED HEIGHT
- EXISTING GRADE
- PROPOSED GRADE

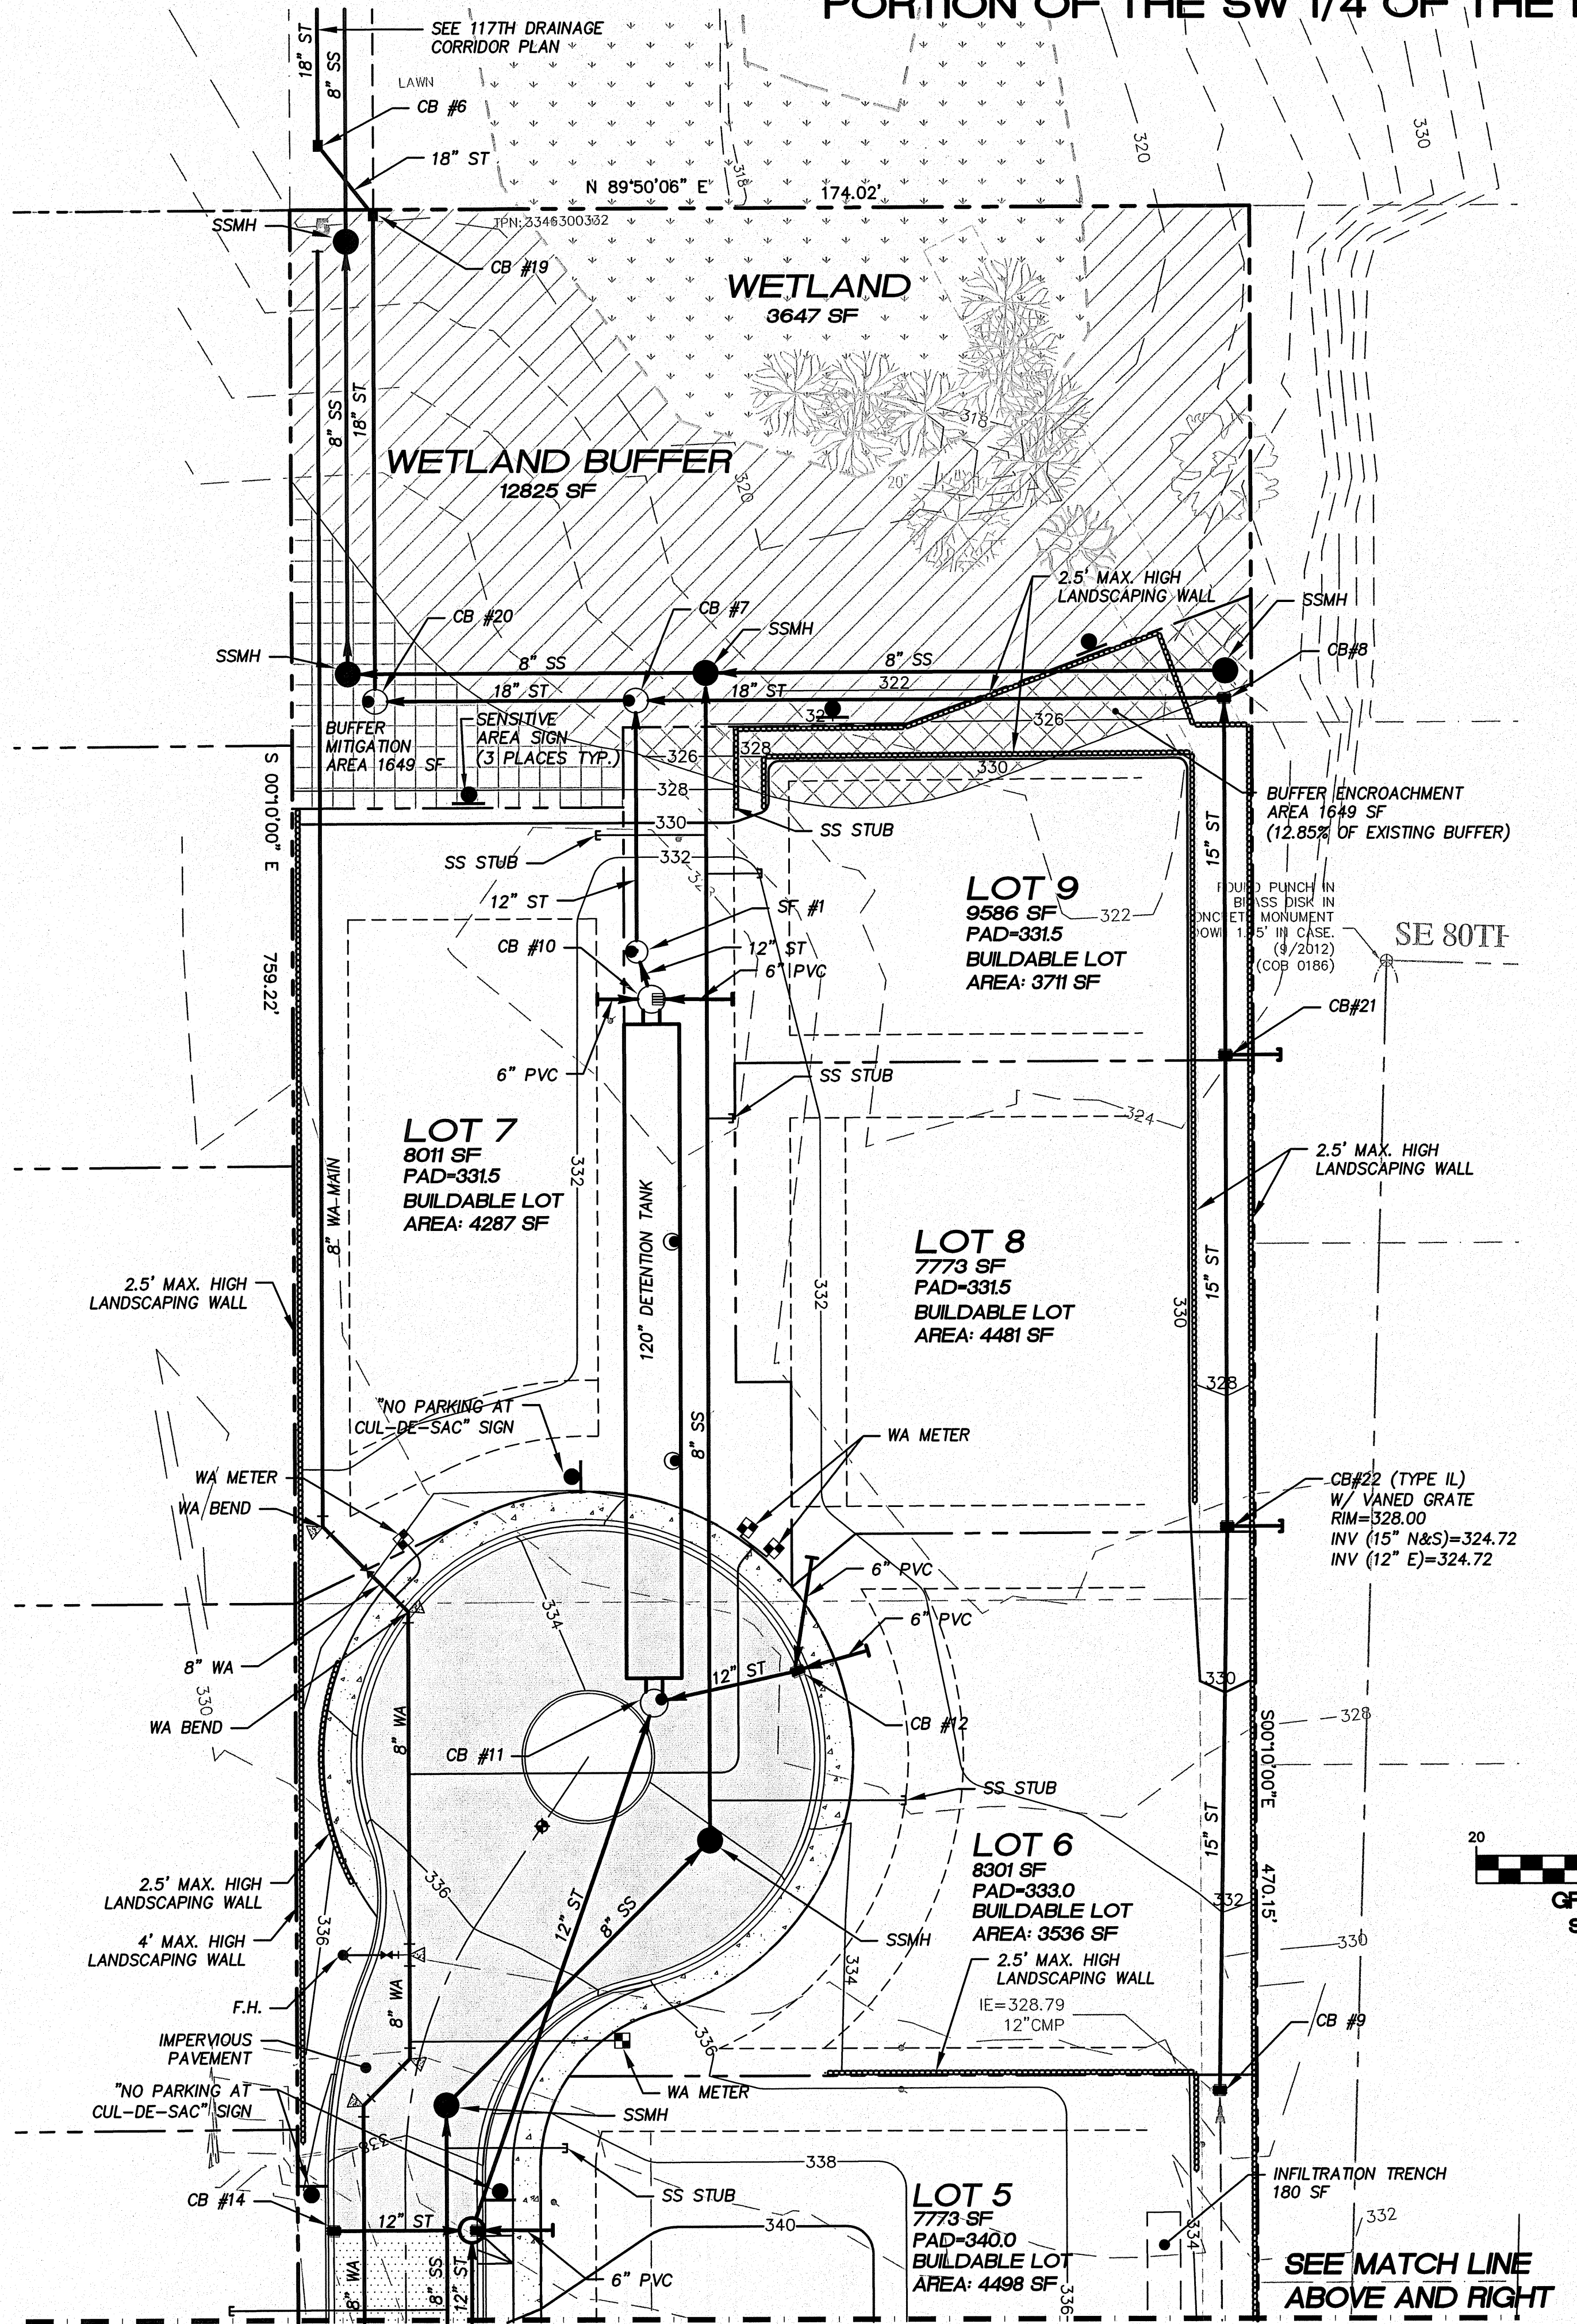

15445 53RD AVE. S.
SEATTLE, WA 98188
PHONE: (206) 431-7970
FAX: (206) 388-1648
WEB SITE: PACENG.COM

Pacific Engineering Design, LLC
Civil Engineering and Planning Consultants

LAWRENCE PARK
CITY OF NEWCASTLE

FOR:
PAUL G. EBENSTEINER
1208 14TH AVENUE SE
BELLEVUE, WA 98004
PHONE: (425) 635-3938

PROJECT NO.: 12025
DRAWN BY: ENM
ISSUE DATE: XX-XX-XXXX
SHEET REV.: 01-03-2013

COMPOSITE UTILITY PLAN AND SEDIMENTATION CONTROL PLAN