
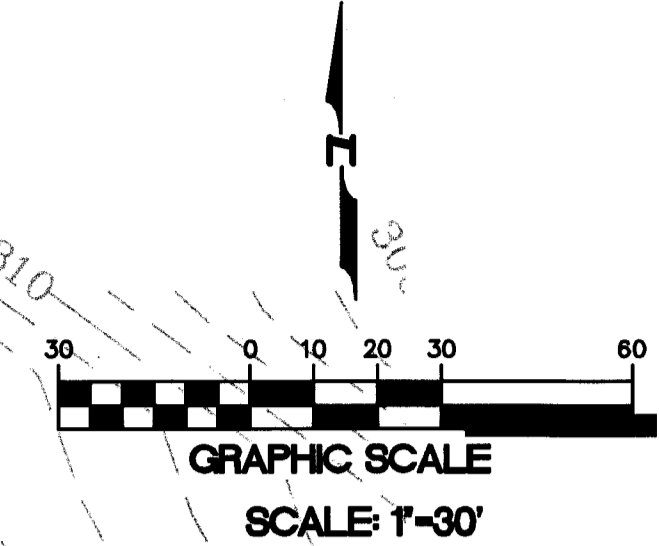


PORTION OF THE SW 1/4 OF THE SW 1/4 OF SEC. 07, TOWNSHIP 23, RANGE 05 E

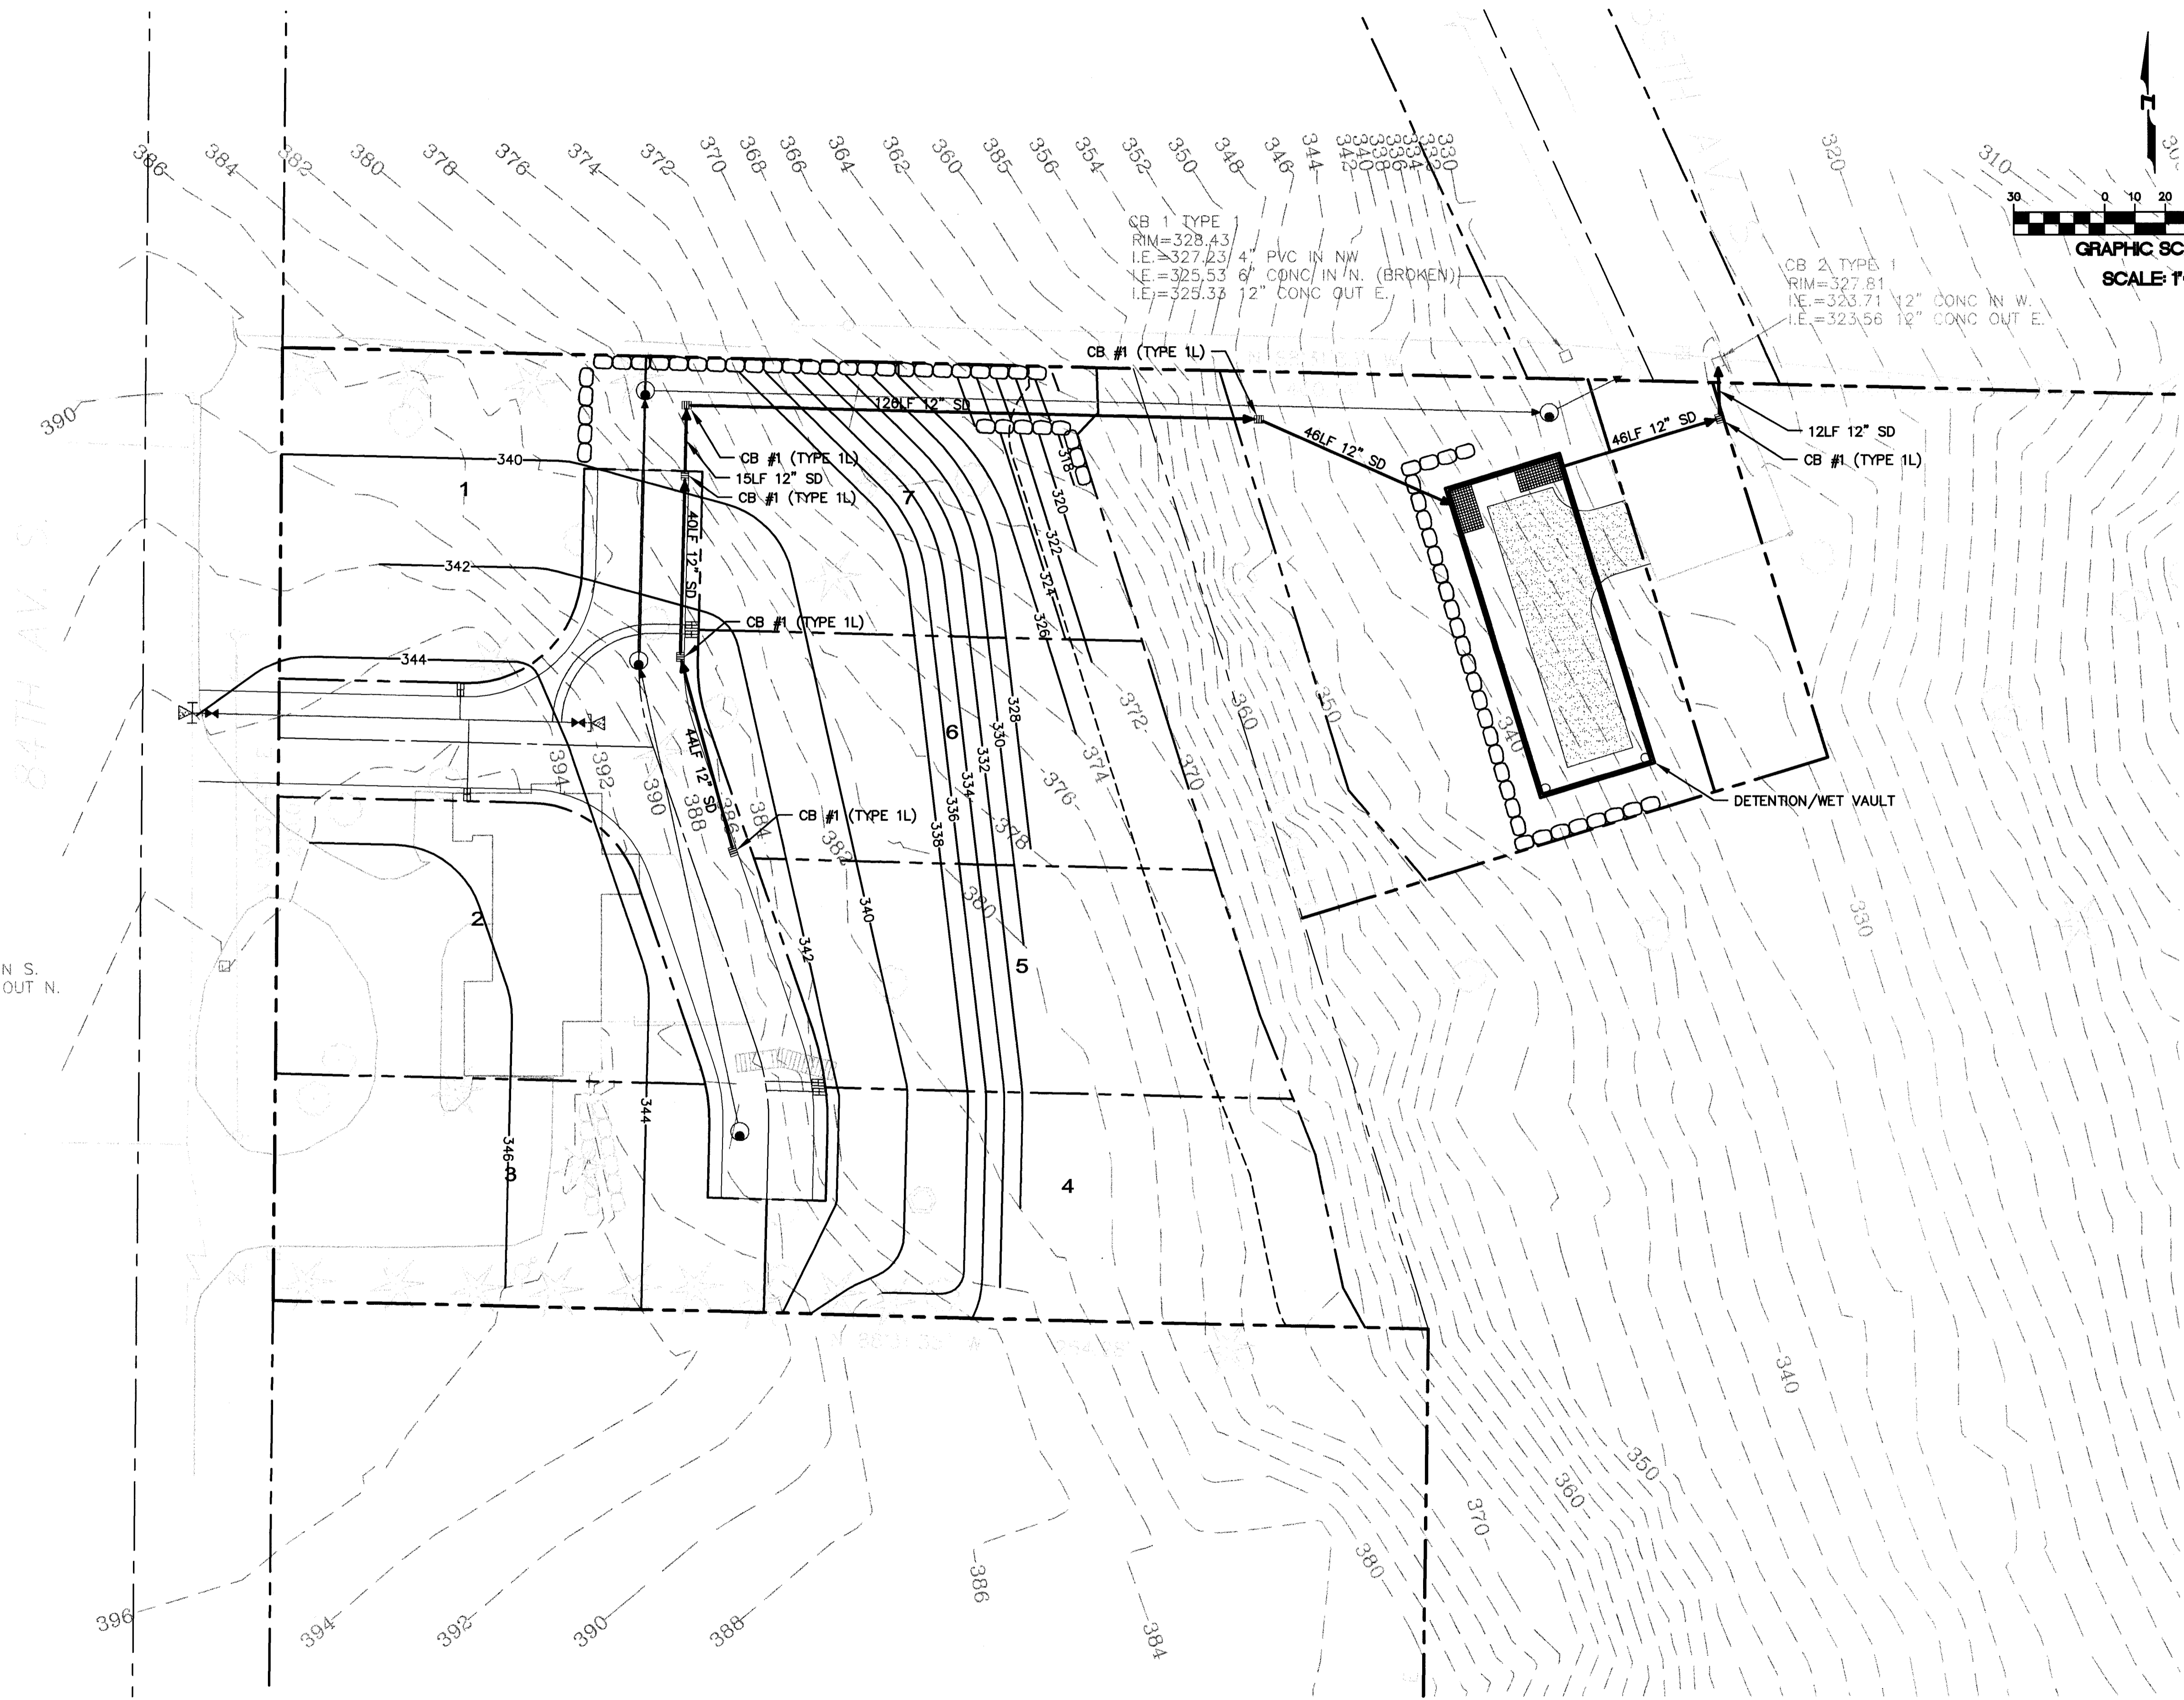

CB 1 TYPE 1
 RIM=328.43
 I.E.=327.23 4\"/>

CB 2 TYPE 1
 RIM=327.81
 I.E.=323.71 12\"/>

CB 5 TYPE 1
 RIM=395.95
 I.E.=394.00 12\"/>

15445 53RD AVE. S.
 SEATTLE, WA 98188
 PHONE: (206) 431-7970
 FAX: (206) 388-1648
 WEB SITE: PACENG.COM

Pacific Engineering Design, LLC
 Civil Engineering and Planning Consultants

WATSON SHORT PLAT
 CITY OF RENTON

FOR:
 DAN JENKINS
 11112 RAINIER AVE S
 SEATTLE, WA 98178
 PHONE: (206) 679-6568

PROJECT NO.: 13033
 DRAWN BY: ENM
 ISSUE DATE: XX-XX-XX
 SHEET REV.:

GRADING AND DRAINAGE PLAN

13033GR01.DWG
P06
 SHEET 06 OF 12